





HARRIMAN UTILITY BOARD		
HARRIMAN TENNESSEE		
SCALE: 1" = 100'	REVISED 12-14-78 <i>RHALL</i>	DWG. <i>RHALL</i>
DATE: 5-2-79		
PLAN AND PROFILE		
795 MCM FEEDER LINE		
		P - 18

NO. 1
HOLE BOOK
CHECKED
DATE
BY

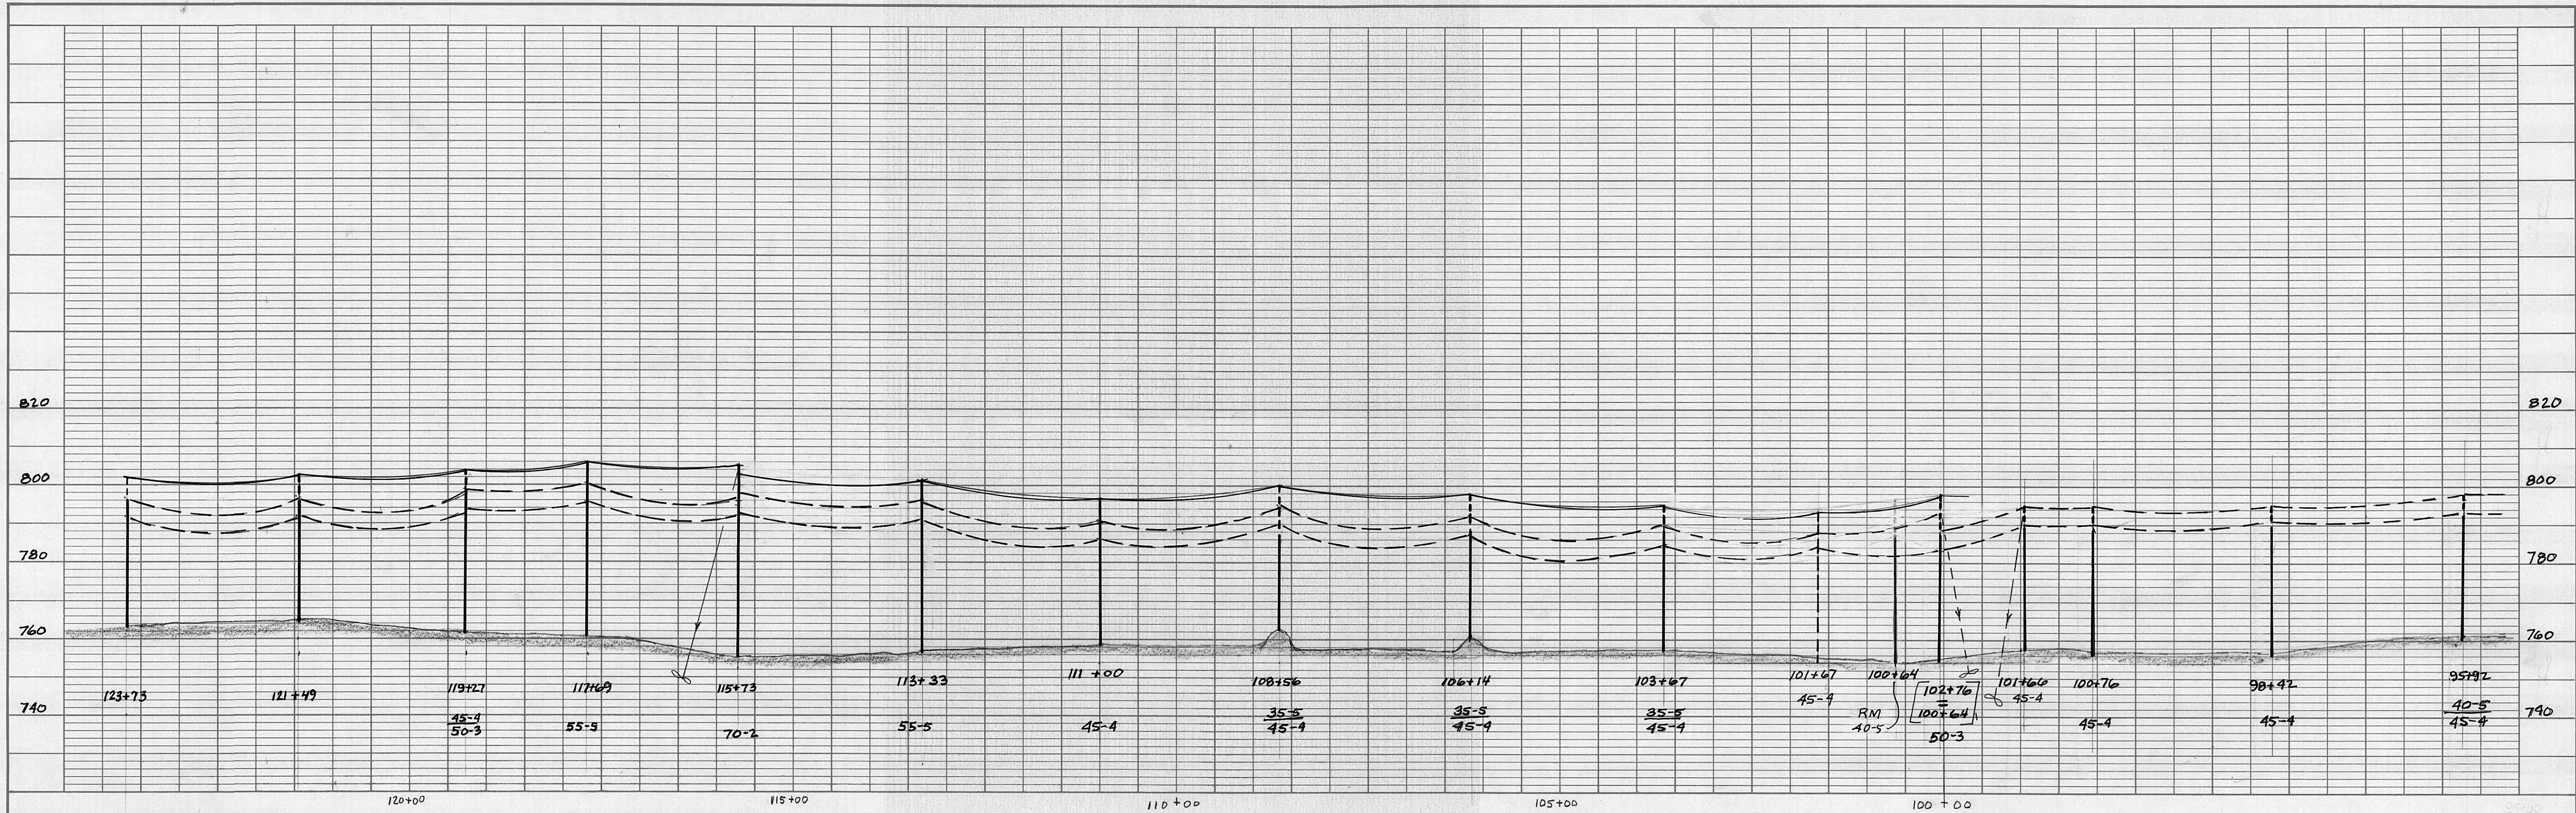

NO. 1
HOLE BOOK
CHECKED
DATE
BY

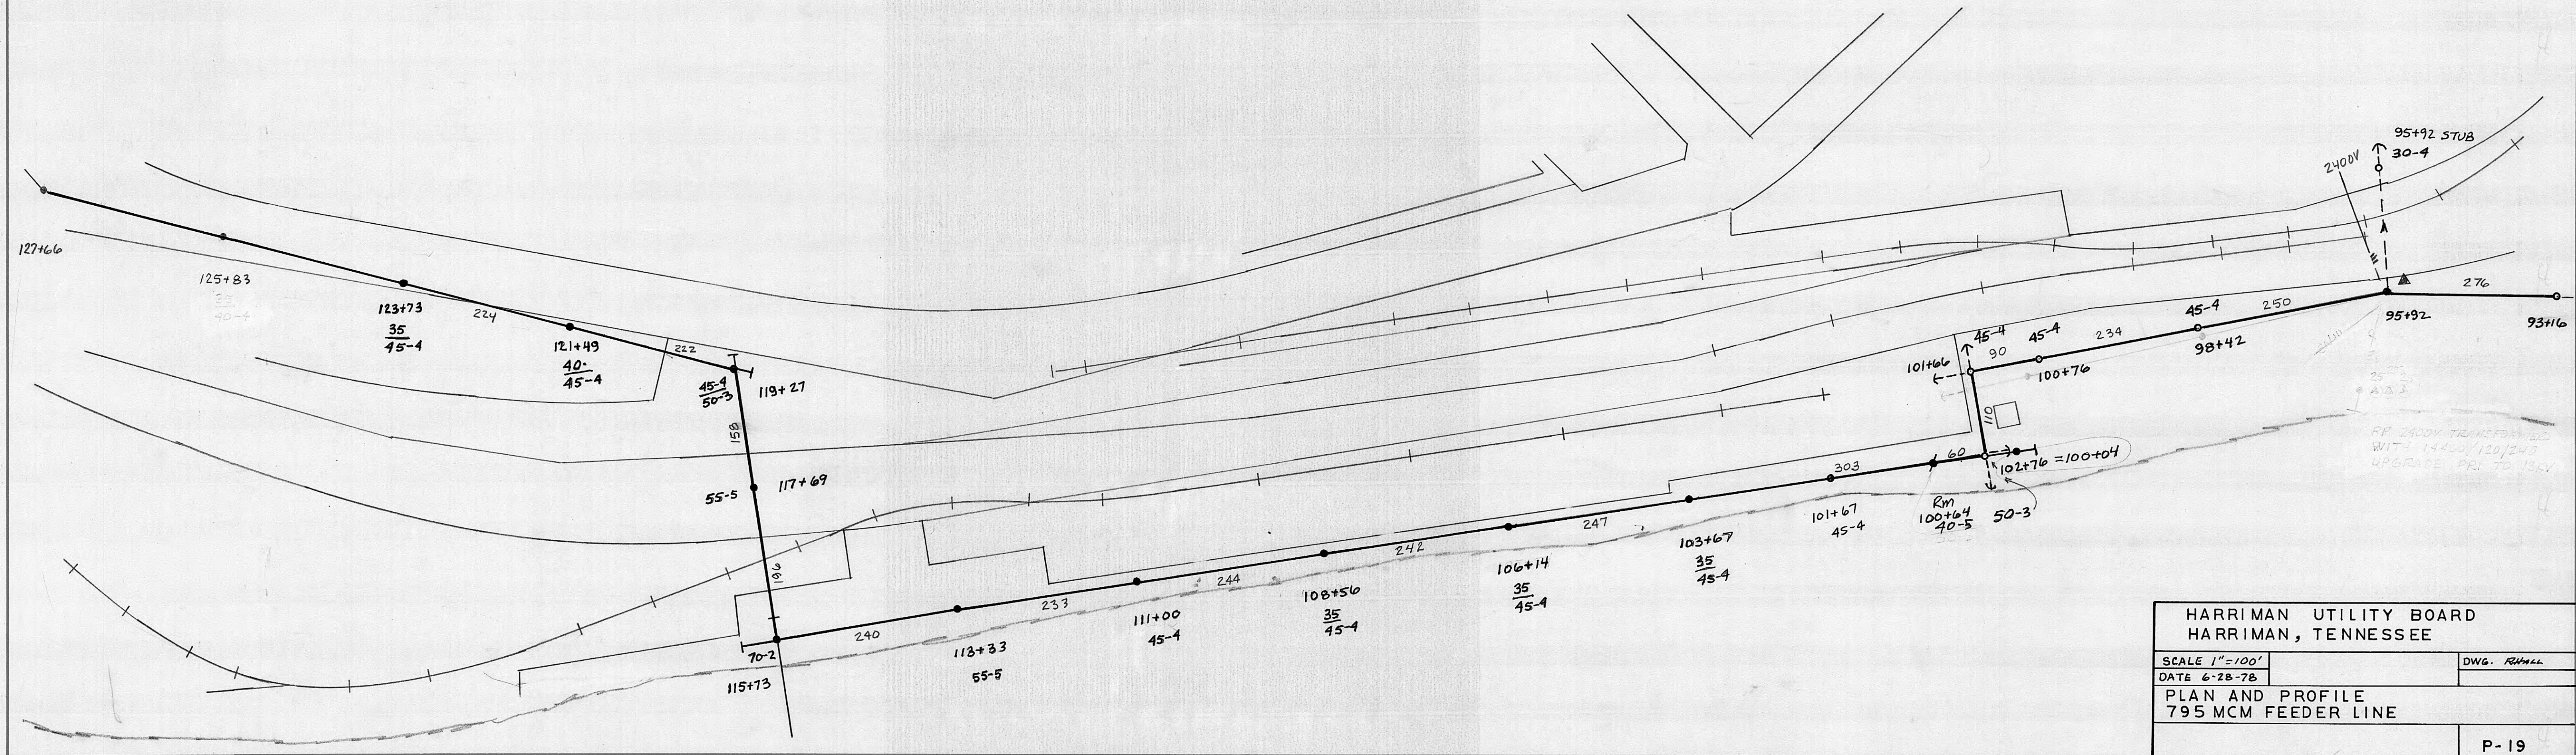


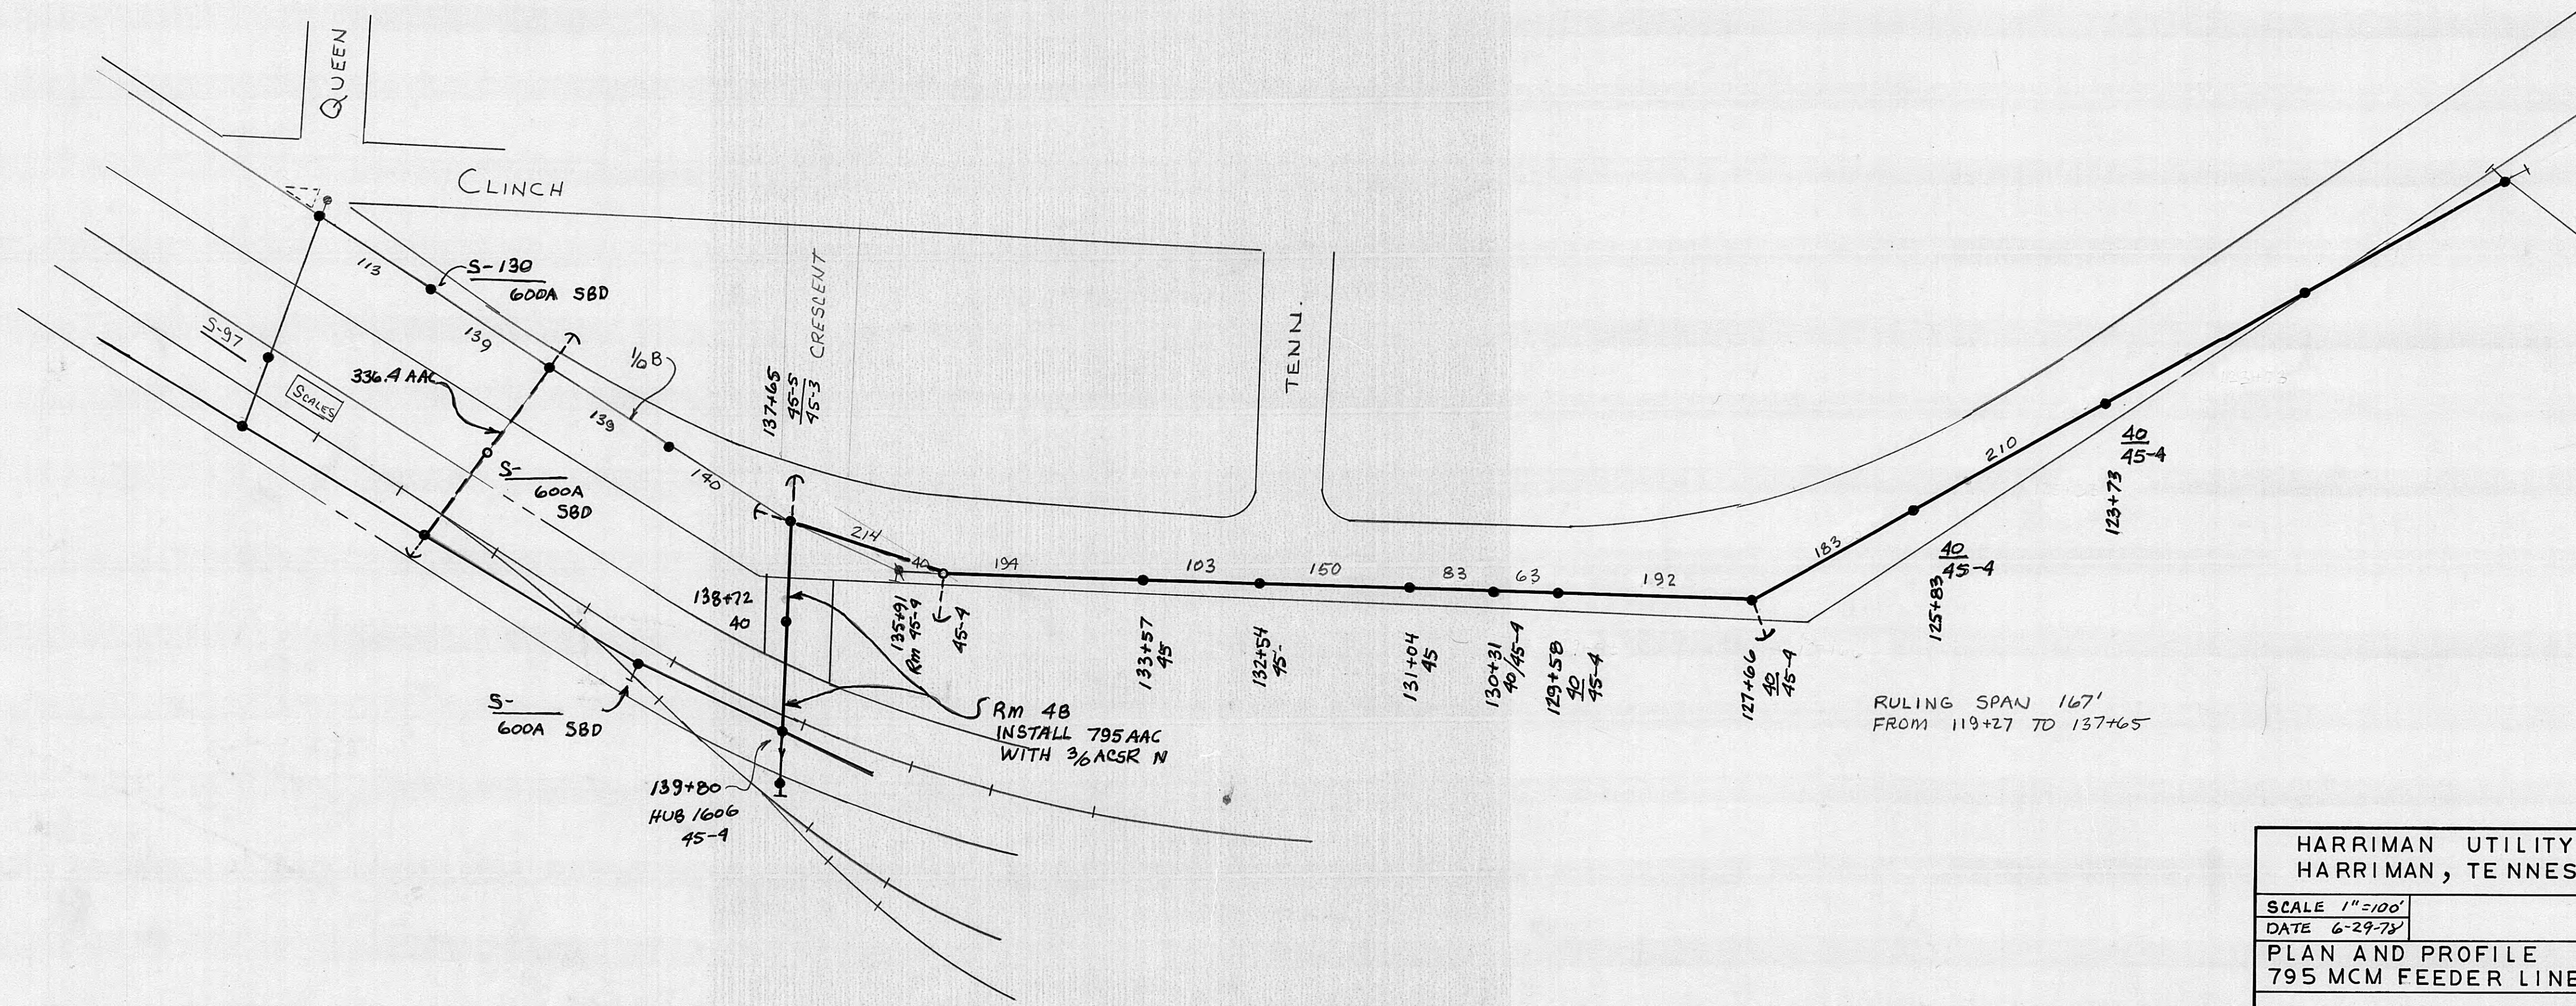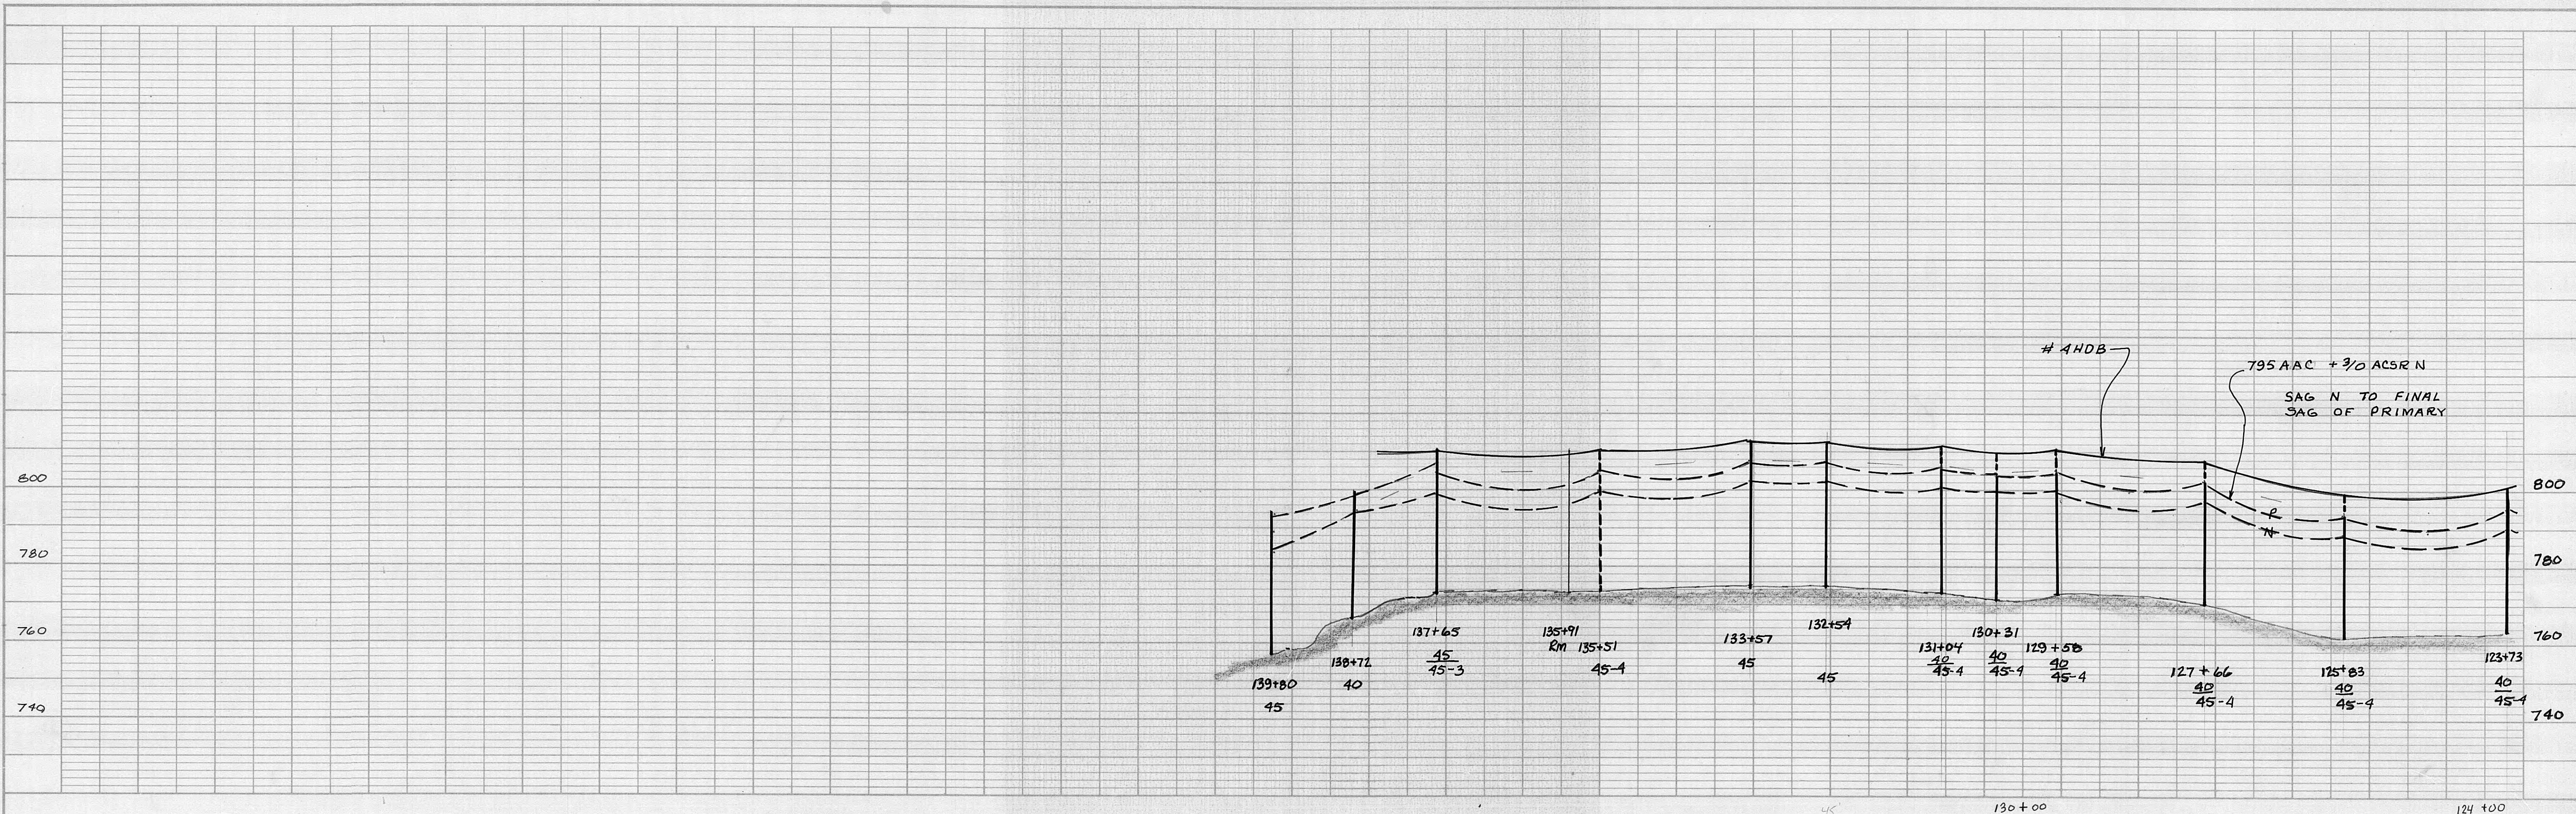

HARRIMAN UTILITY BOARD HARRIMAN, TENNESSEE	
SCALE 1"=100'	DWG. R.HALL
DATE 6-29-78	
PLAN AND PROFILE 795 MCM FEEDER LINE	
P-20	

PROFILE	DATE
NOTE BOOK	BY
1. M. H. HALL	DATE
STRUCTURE LOCATION SHEET	

PLAN	DATE
NOTE BOOK	BY
1. M. H. HALL	DATE
STRUCTURE LOCATION SHEET	

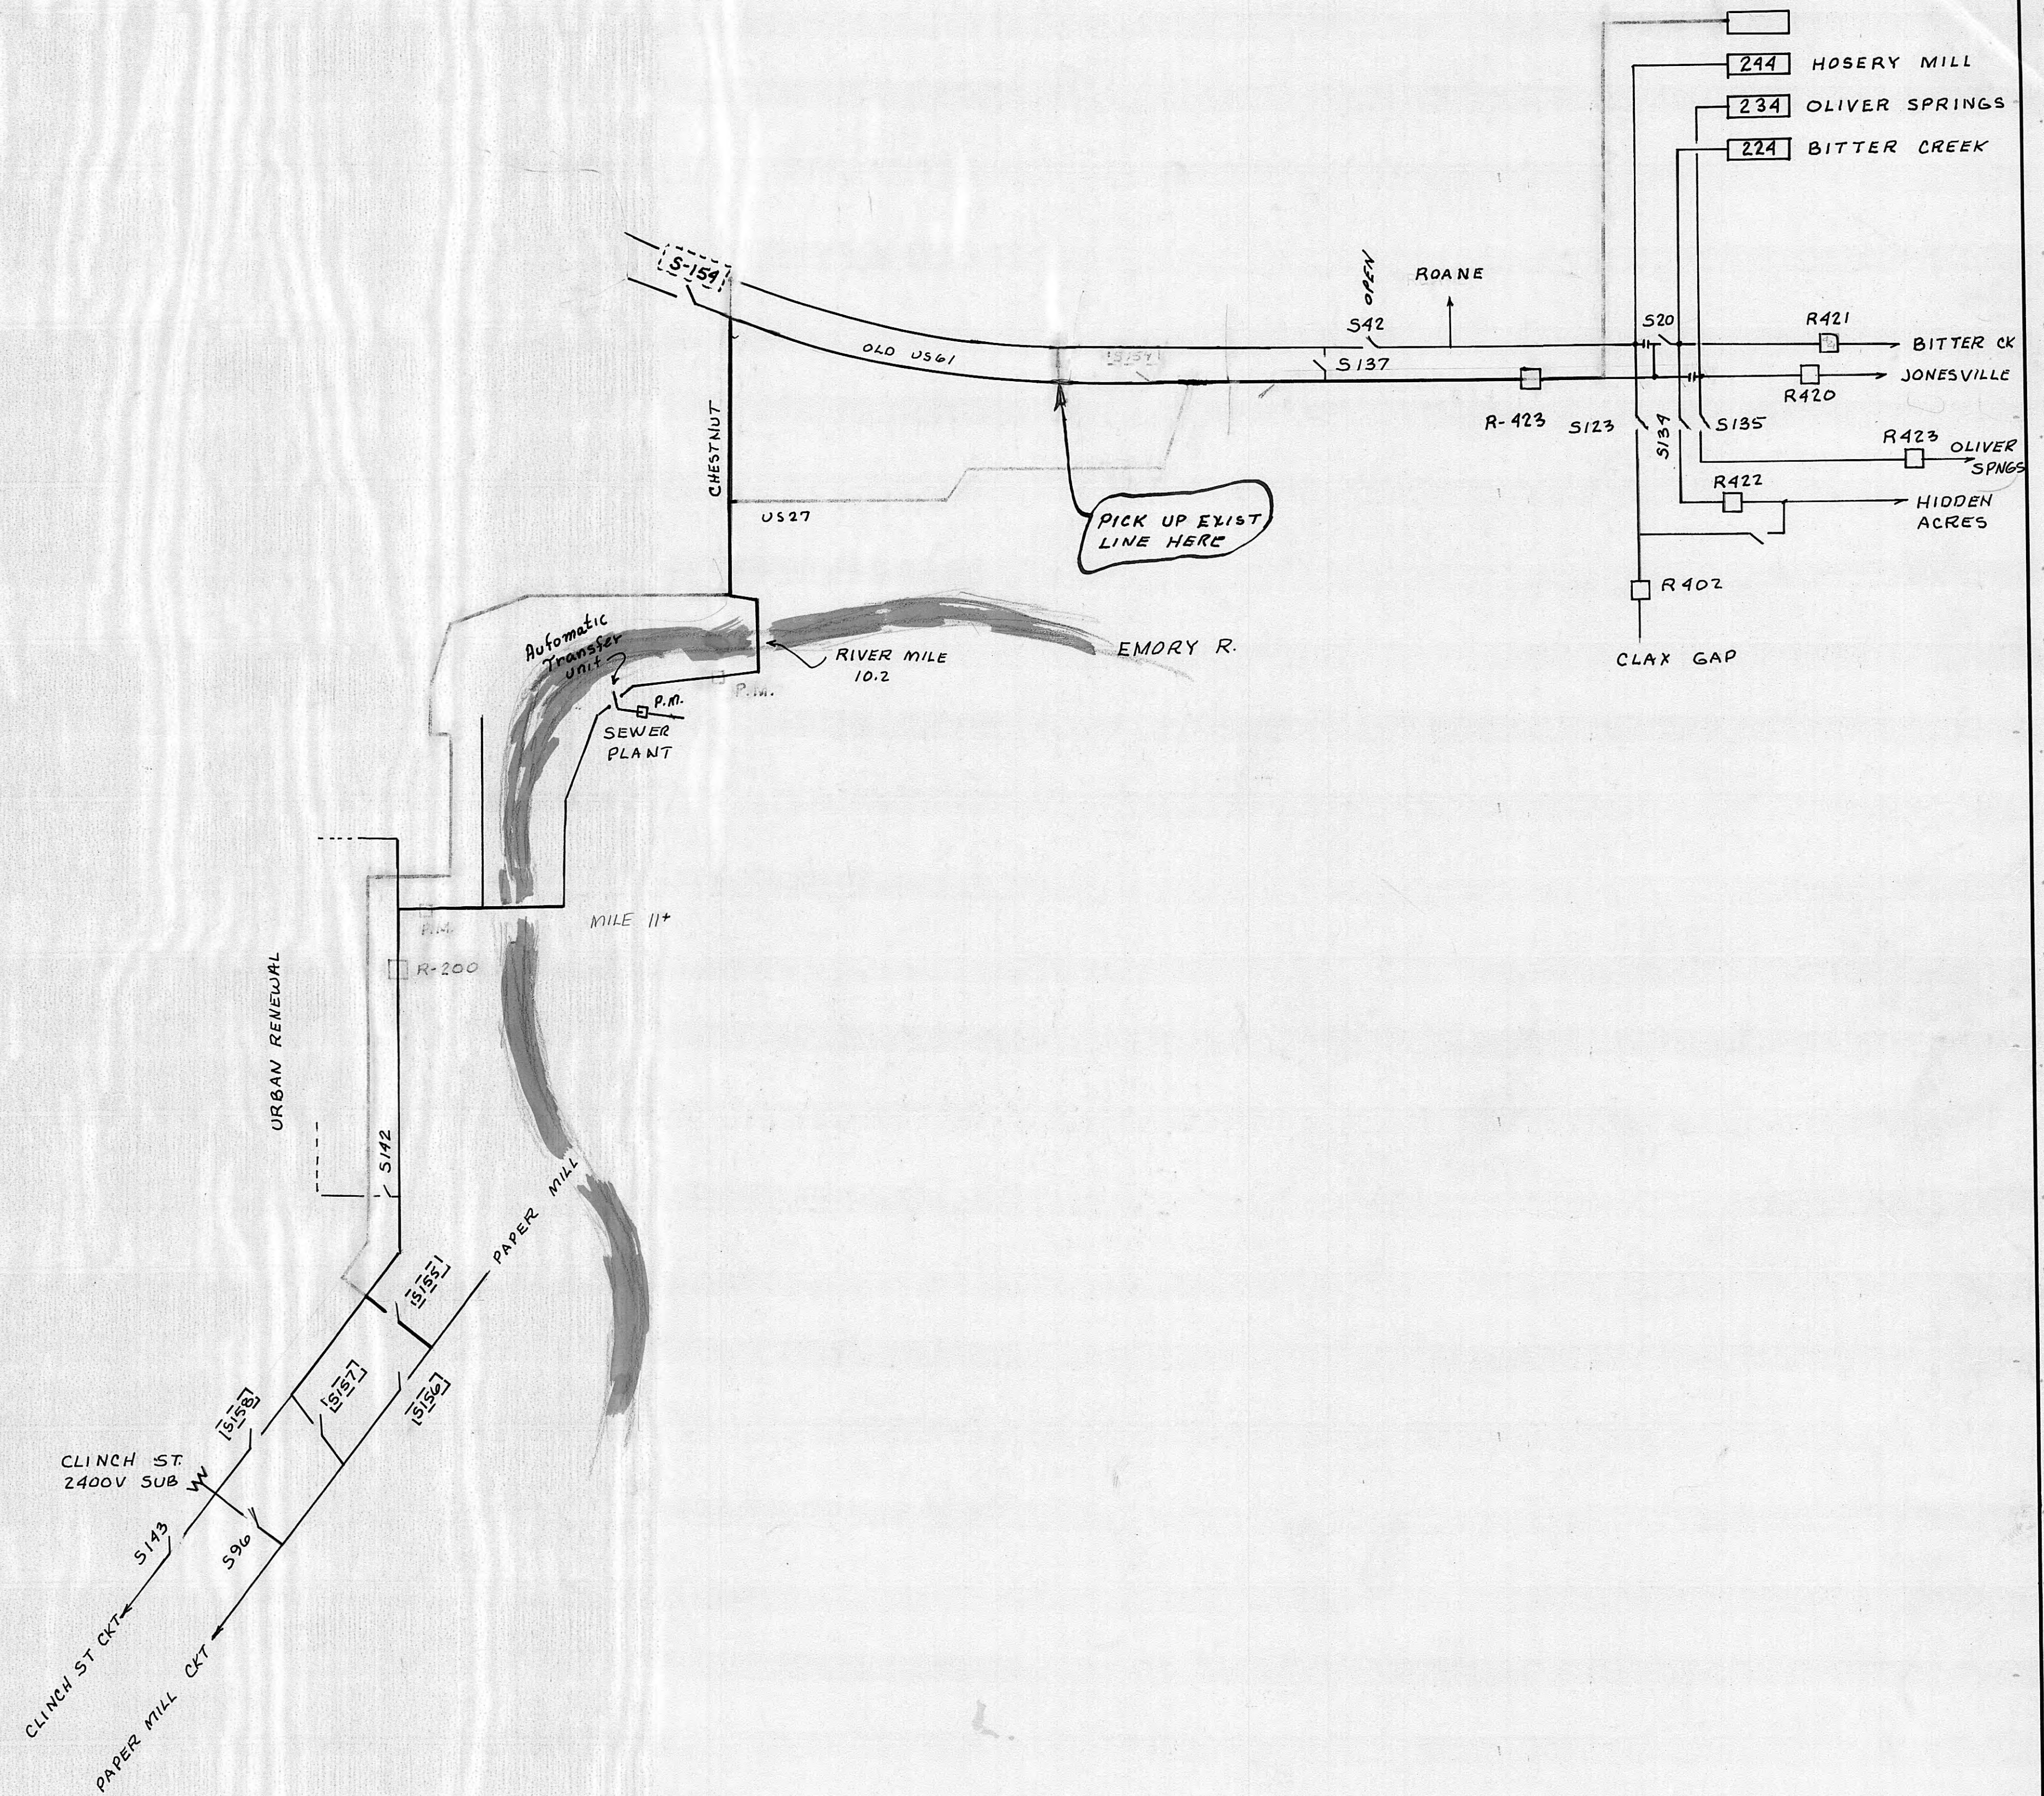

Rev: 6-3-86 *hah*

HARRIMAN UTILITY BOARD
HARRIMAN, TENNESSEE

SCALE: N.T.S. APPROVED BY: DRAWN BY: *RHALL*

DATE: 8-1-78

SINGLE LINE DIAGRAM
795 MCM FEEDER LINE

DRAWING NUMBER
P-2 2