



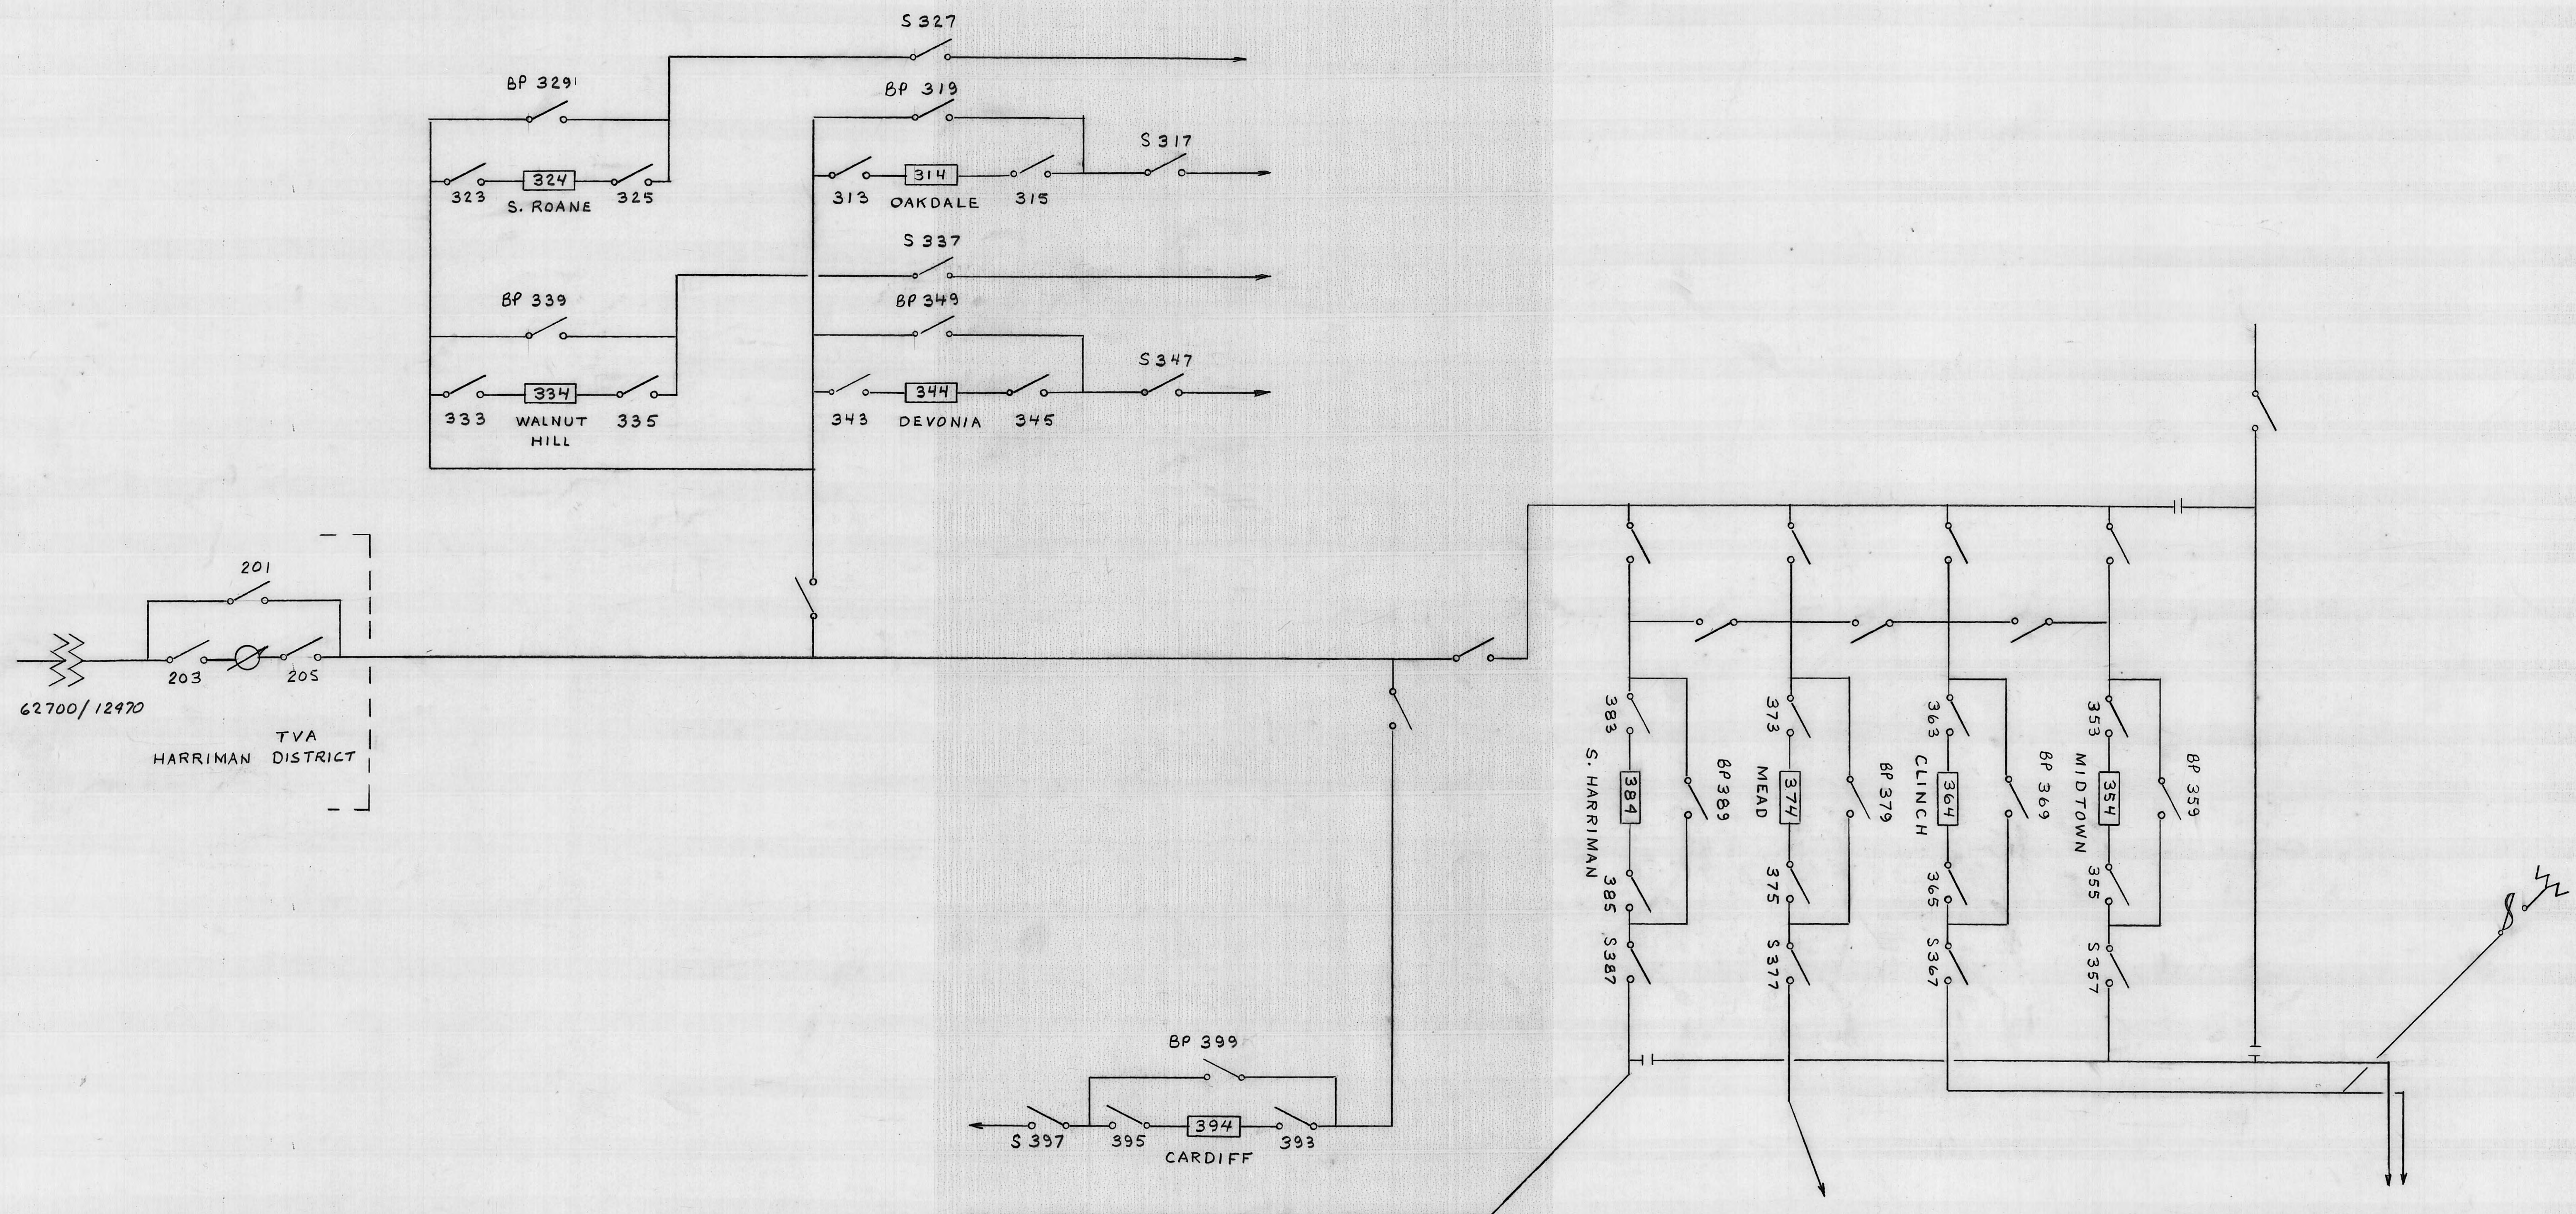

Return to Engineering Flat File Drawer 4

HARRIMAN UTILITY BOARD HARRIMAN, TENNESSEE	
SCALE:	APPROVED BY
DATE: 3-20-80	DRAWN BY: R. HALL
SINGLE LINE DIAGRAM 13.2 KV SWITCHING STATION. DISTRICT	
	DRAWING NUMBER P-29

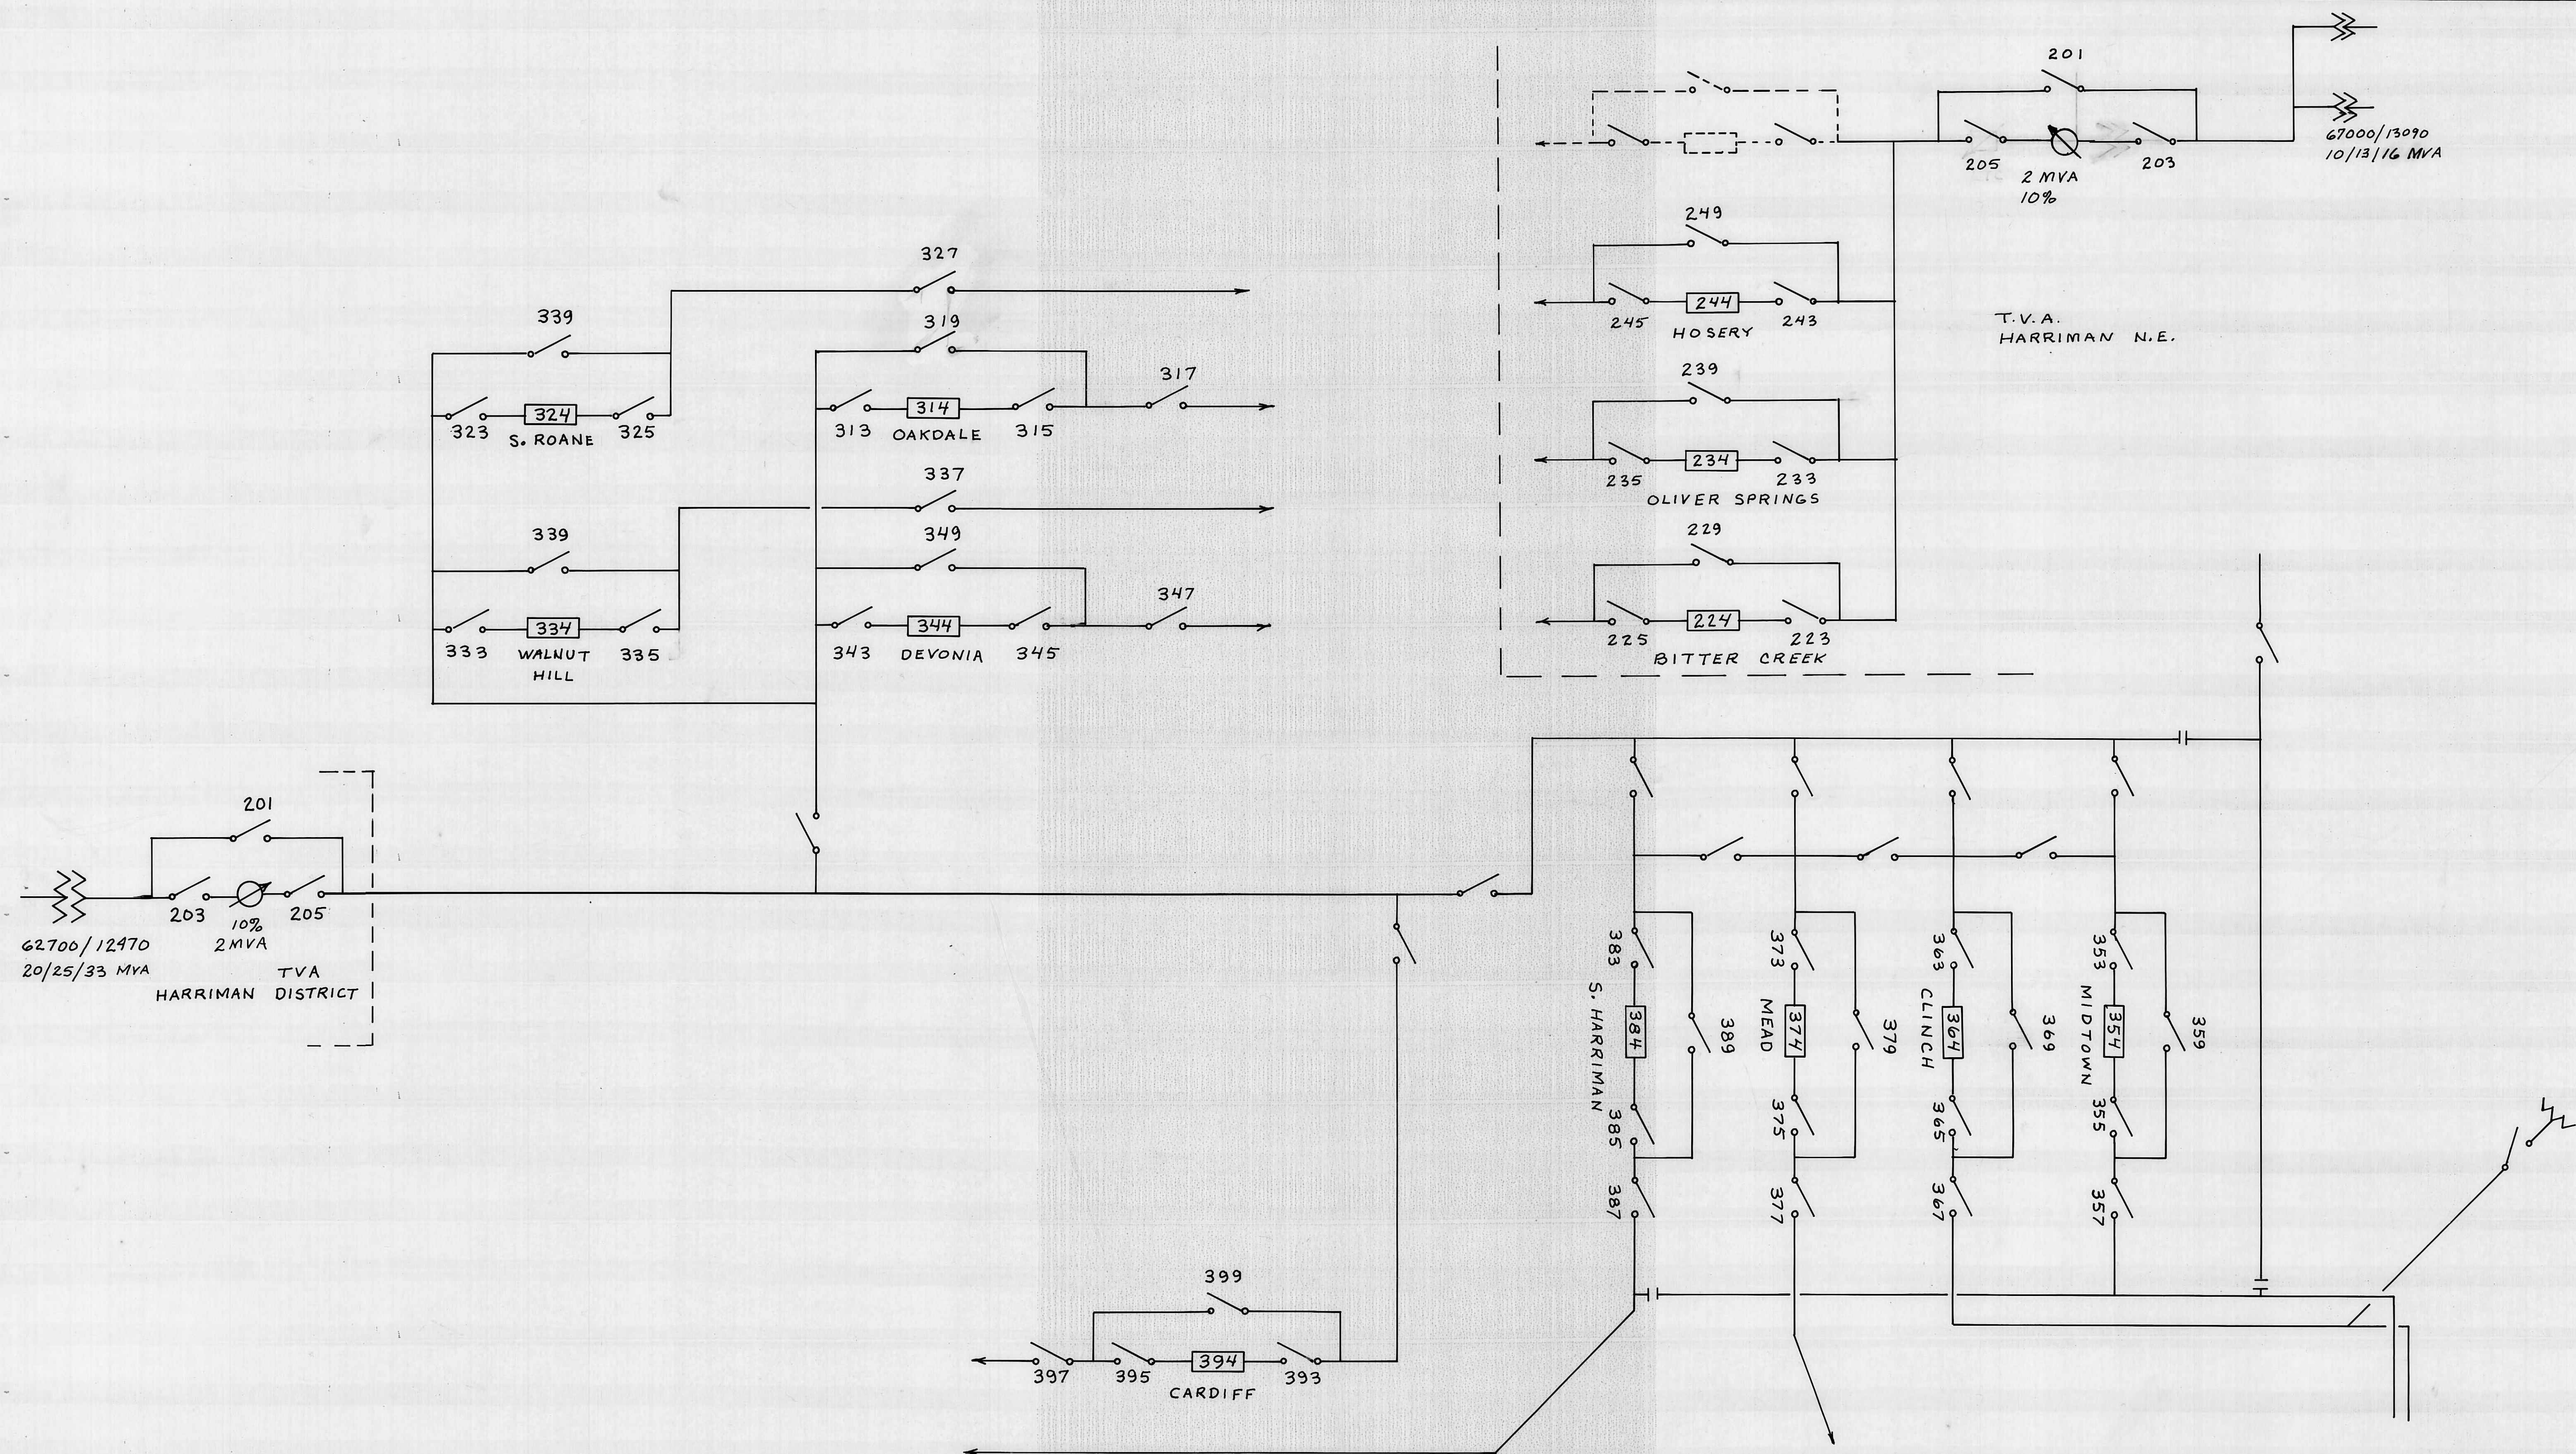

HARRIMAN UTILITY BOARD HARRIMAN, TENNESSEE		
SCALE:	APPROVED BY:	DRAWN BY:
DATE:		
		DRAWING NUMBER
		P 29

Return to Engineering
Flat File Drawer 4