



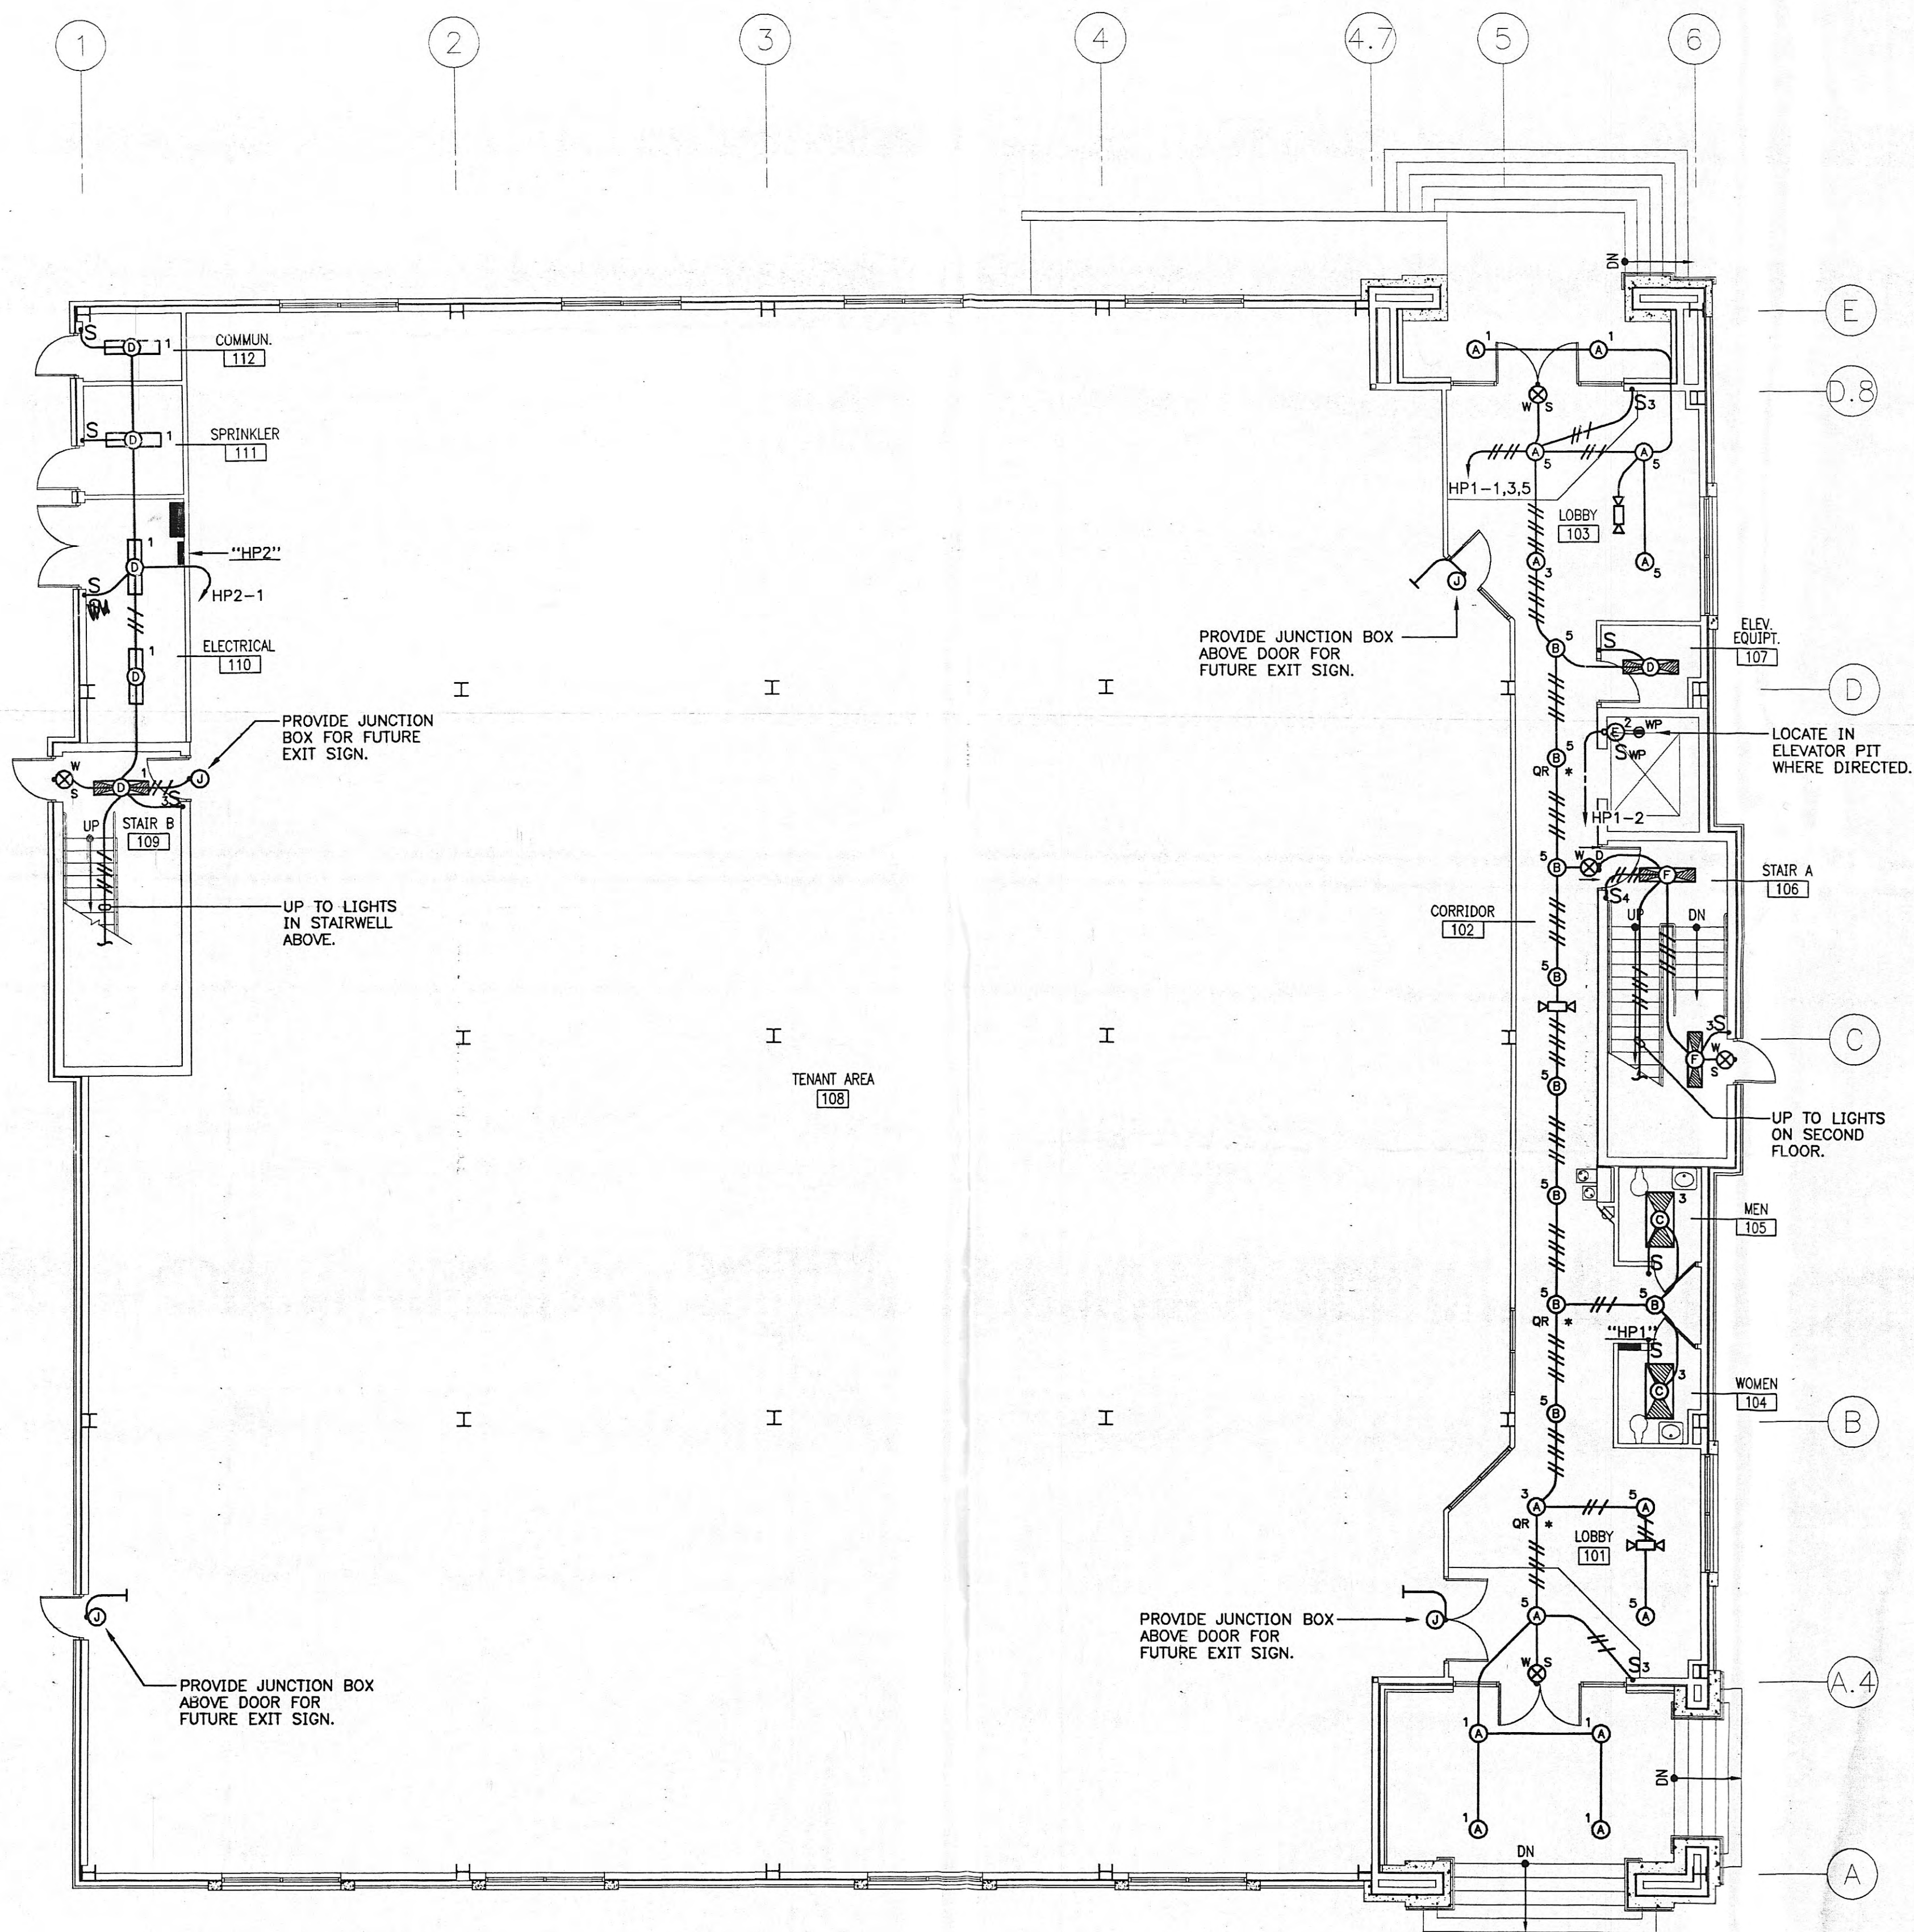

FIRST FLOOR PLAN - LIGHTING
SCALE: 1/8" = 1'-0"

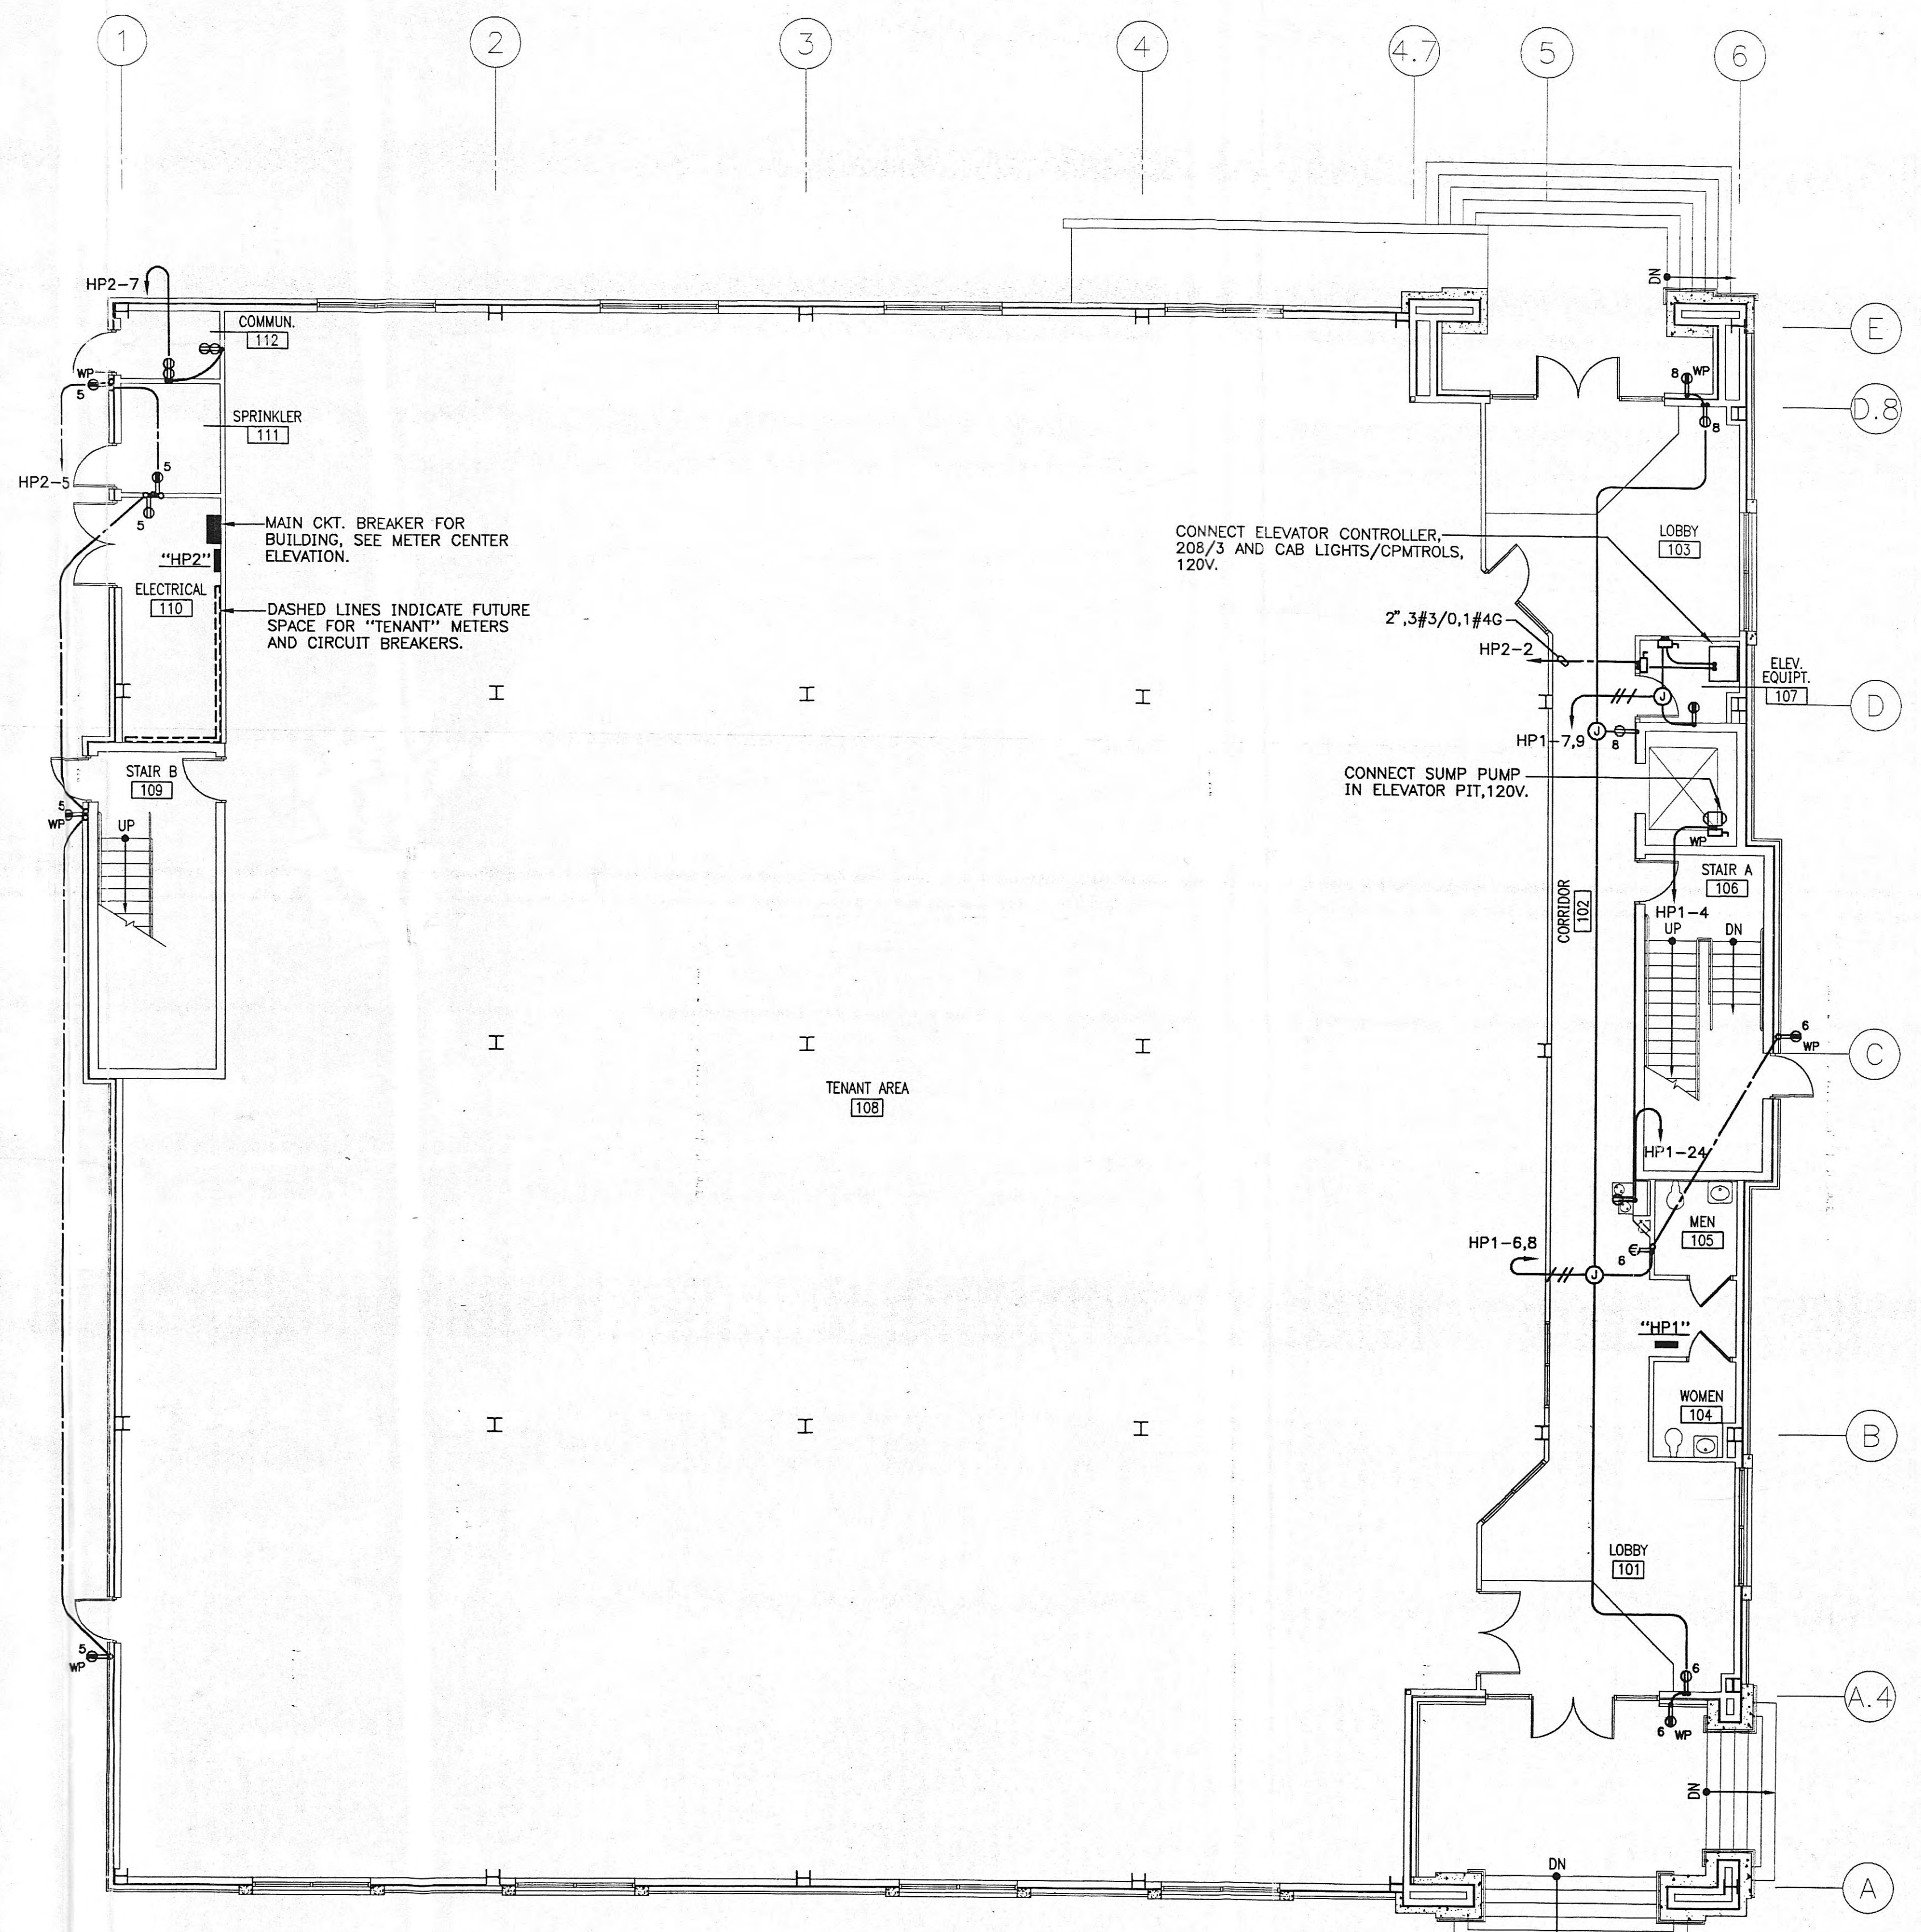

FIRST FLOOR PLAN - POWER
SCALE: 1/8" = 1'-0"

**PRELIMINARY
NOT FOR CONSTRUCTION**

Vreeland Engineers Inc.
3107 Sutherland Ave.
P.O. Box 10645
Knoxville, TN 37938
TEL: (423) 637-4451
FAX: (423) 637-1558
WATS: 800-362-9788

Harriman Medical Plaza


Harriman, Tennessee

FIRST FLOOR PLAN

A New Facility For:

NOT FOR CONSTRUCTION

**THE LEWIS GROUP
ARCHITECTS**
4709 PAPER MILL ROAD • ONE COLONY PARK
SUITE 103 • KNOXVILLE, TN 37909 • 1900
PH. 423.564.5000 FX. 423.568.1272 E. lewisgrp@aol.net

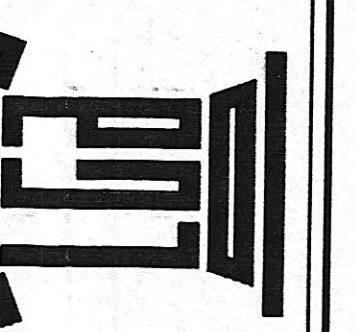


THIS DRAWING IS THE PROPERTY OF THE LEWIS GROUP ARCHITECTS, INC. AND IS TO BE USED ONLY FOR THE PROJECT AND DATE SPECIFICALLY NOTED ON ANY OTHER PROJECTS WITHOUT THE WRITTEN PERMISSION OF THE LEWIS GROUP ARCHITECTS, INC. NO PART OF THIS DRAWING OR ANY INFORMATION HEREON SHALL BE REPRODUCED OR TRANSMITTED IN ANY FORM OR BY ANY MEANS, ELECTRONIC OR MECHANICAL, WITHOUT THE WRITTEN PERMISSION OF THE LEWIS GROUP ARCHITECTS, INC.

Project Number
9845


8/2/99
E1.1

Harriman Medical Plaza - Site Electrical.dwg
J.J.D. 09/11/99 11:18 AM HD99165(HD)

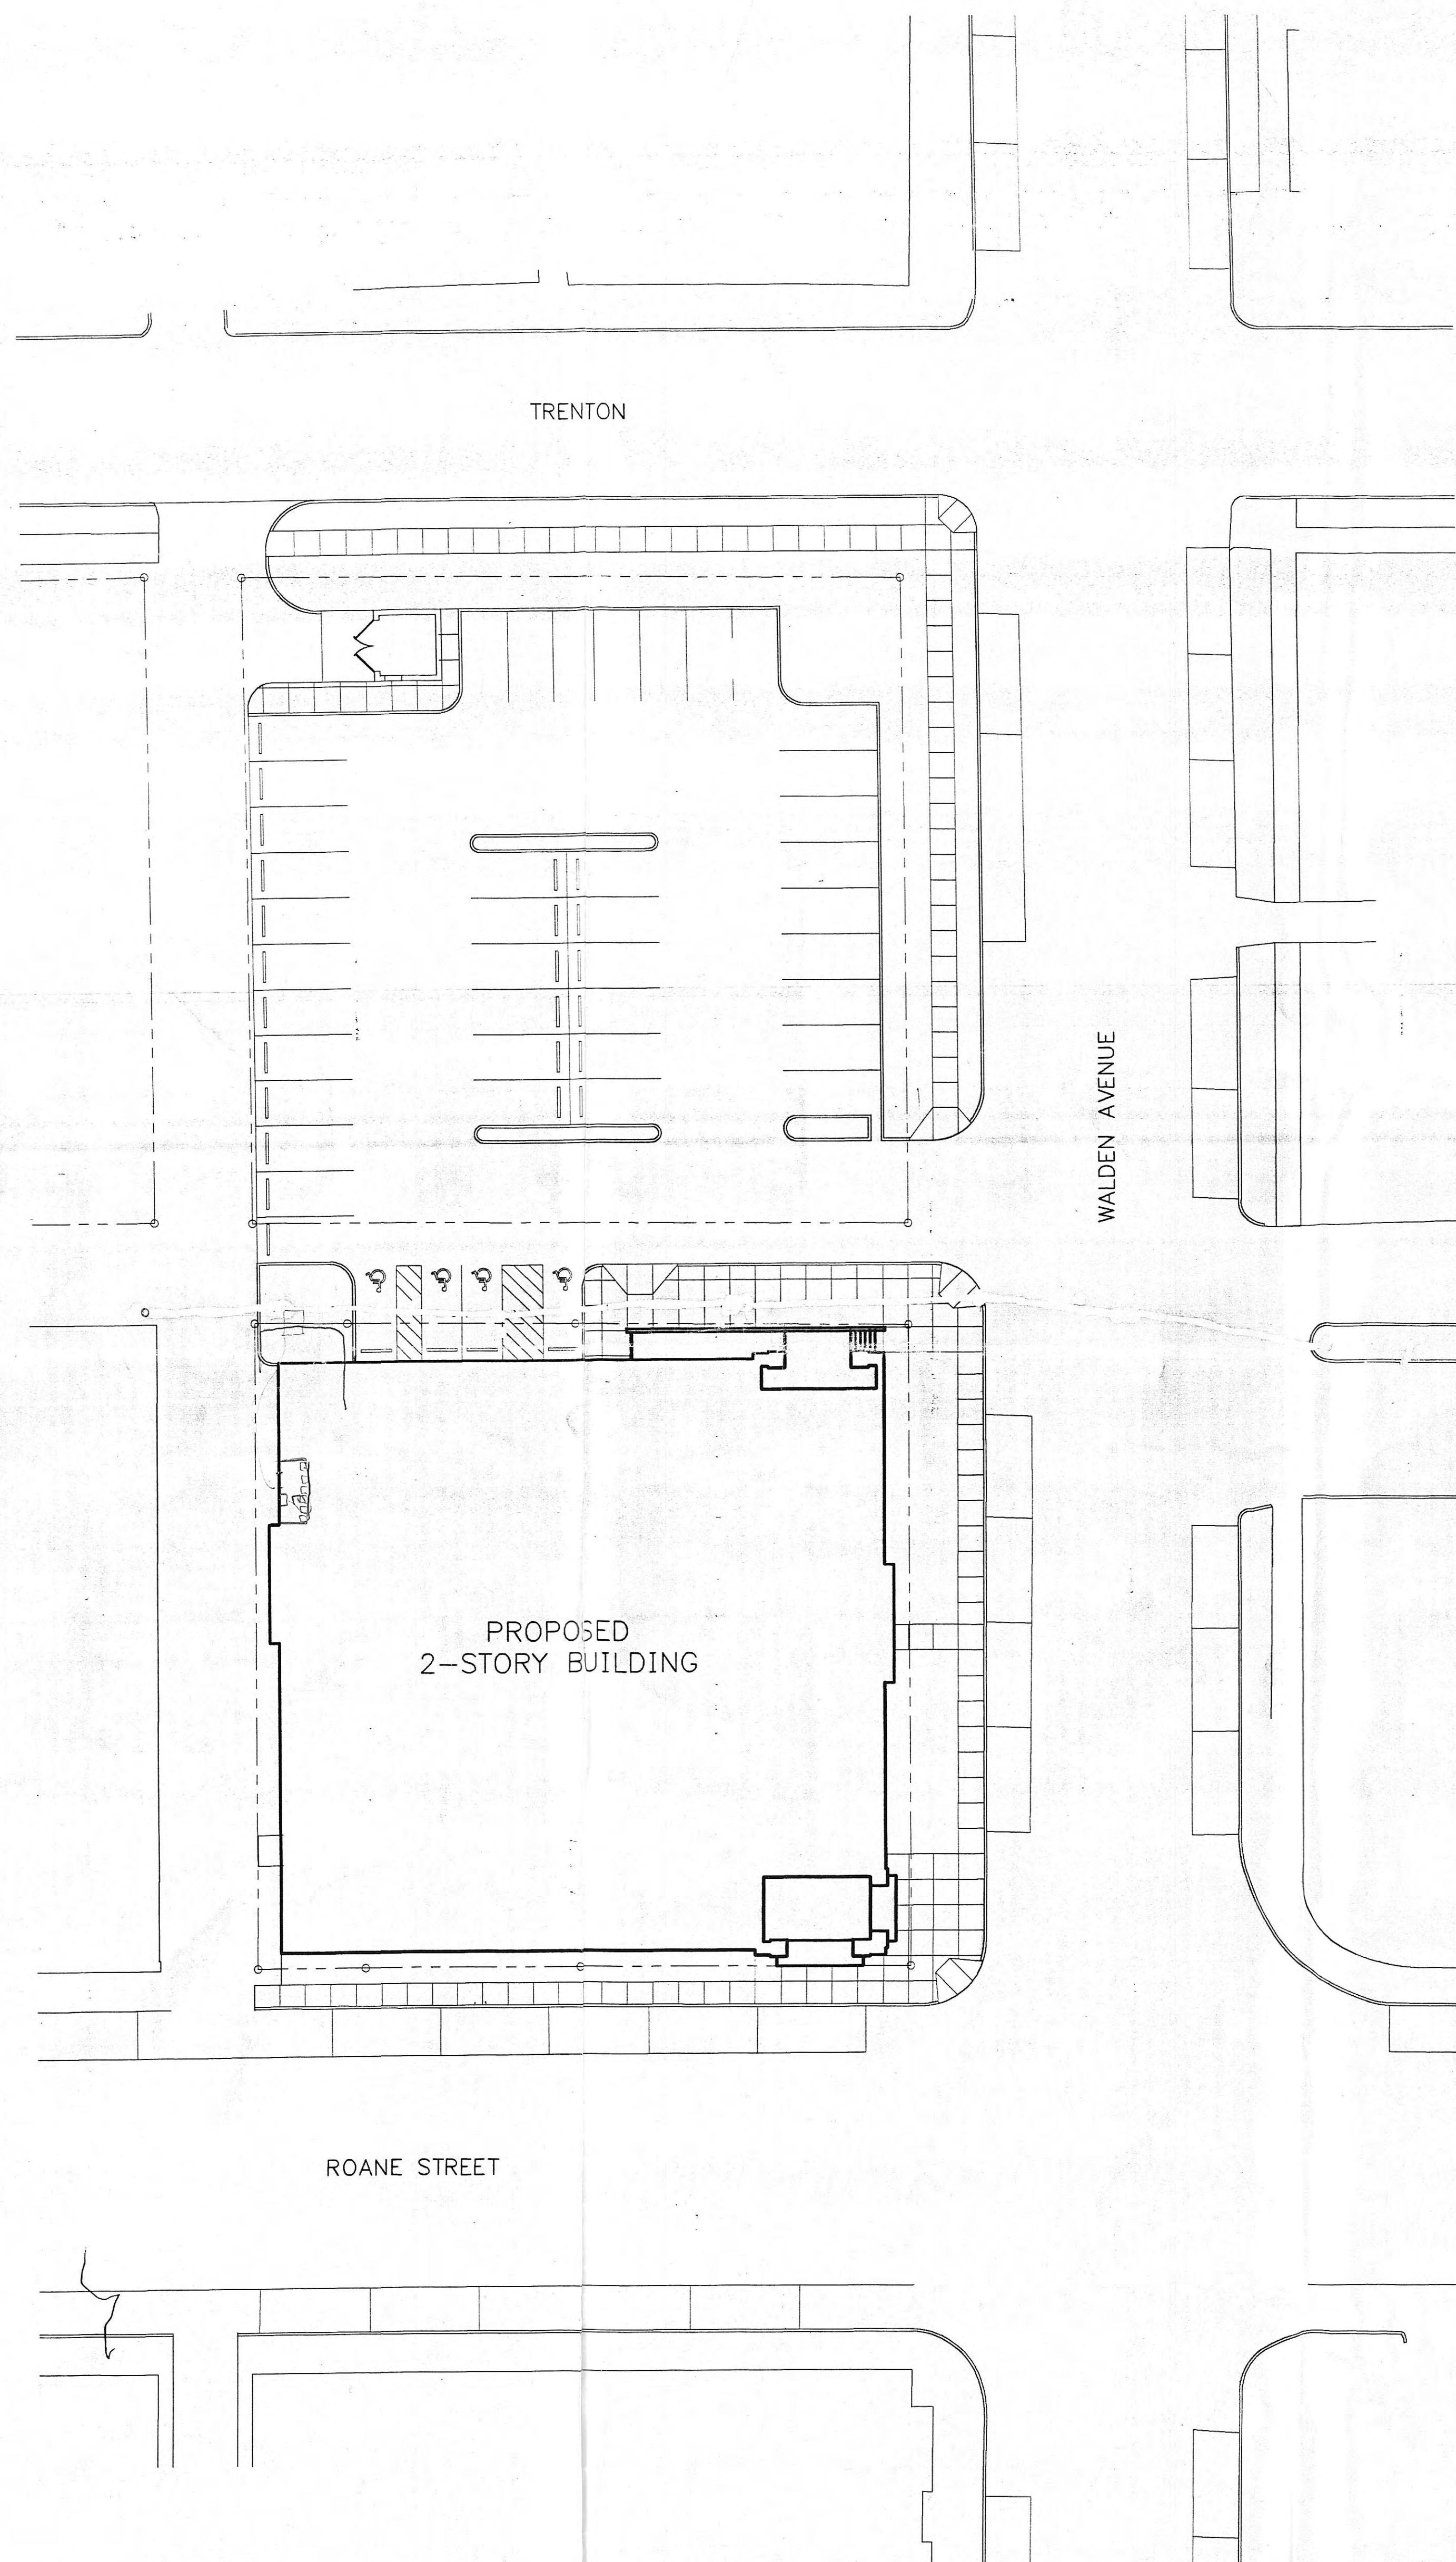

SITE PLAN - ELECTRICAL
SCALE: 1"=20'-0"

Vreeland Engineers Inc.
3107 Sutherland Ave.
P.O. Box 10648
Knoxville, TN 37939
PH: (423) 637-4451
FAX: (423) 637-1056
TATS: 800-362-9789

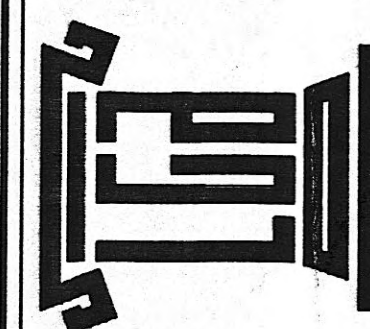

**THE LEWIS GROUP
ARCHITECTS**
4709 PAPER MILL ROAD • ONE COLONY PARK
SUITE 103 • KNOXVILLE, TN 37909 • 1900
PH. 423.584.5000 FX. 423.586.1272 E. lewisgrp@usit.net

THIS DRAWING IS THE PROPERTY OF THE LEWIS GROUP ARCHITECTS. IT IS TO BE USED ONLY FOR THE PROJECT AND NOT FOR ANY OTHER PROJECT. NO PART OF THIS DRAWING IS TO BE REPRODUCED OR TRANSMITTED IN ANY FORM OR BY ANY MEANS, ELECTRONIC OR MECHANICAL, INCLUDING PHOTOCOPYING, RECORDING, OR BY ANY INFORMATION STORAGE AND RETRIEVAL SYSTEM, WITHOUT THE WRITTEN PERMISSION OF THE LEWIS GROUP ARCHITECTS. THE LEWIS GROUP ARCHITECTS, P.C., AND SHALL NOT BE LIABLE FOR ANY DAMAGES, INCLUDING CONSEQUENTIAL DAMAGES, ARISING OUT OF OR FROM THE USE OF THIS DRAWING. IT IS TO BE REPRODUCED UPON REQUEST.

Project Number
9845
2/99
SE1.1

Harriman Medical Plaza
A New Facility For:
Harriman, Tennessee
SITE PLAN - ELECTRICAL