




SOUTH ELEVATION
Scale $\frac{1}{4}'' = 1'-0''$

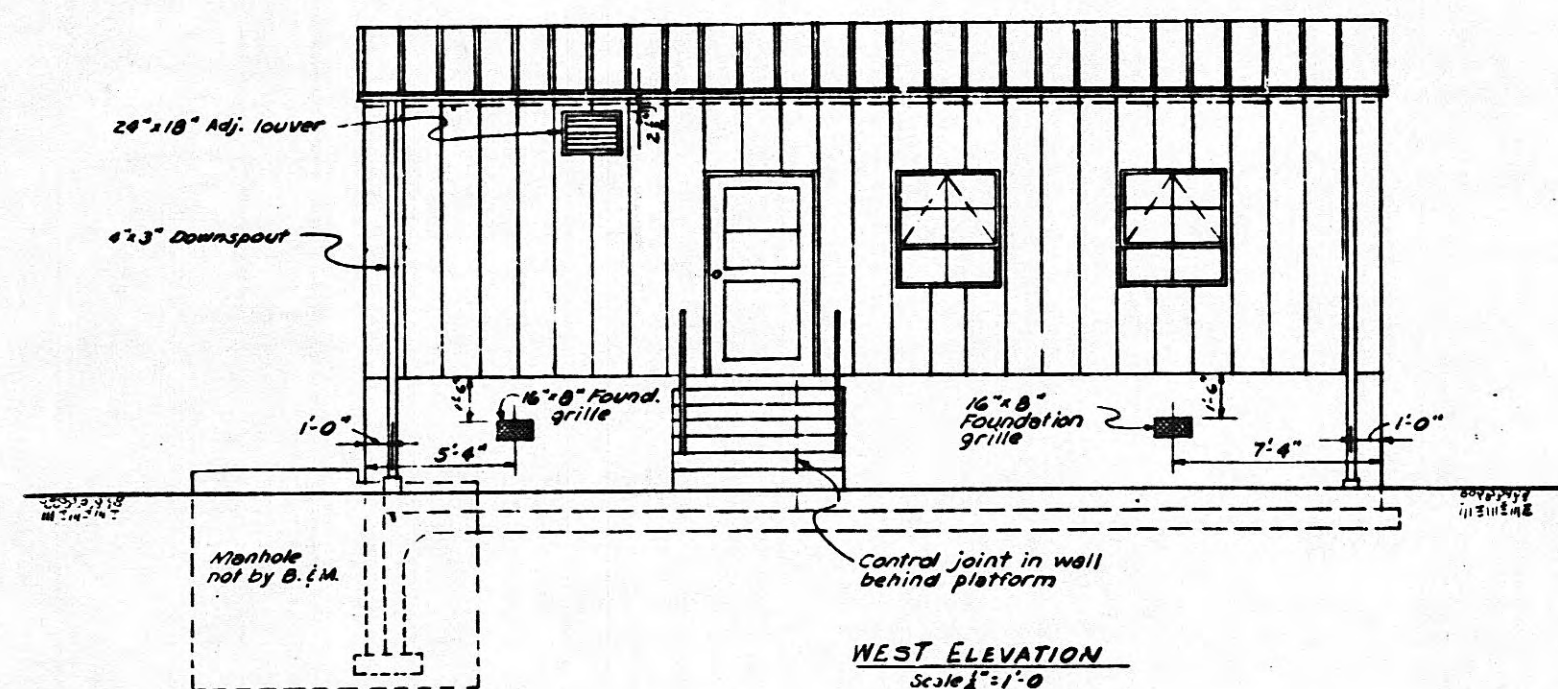

WEST ELEVATION
Scale $\frac{1}{4}" = 1'-0"$

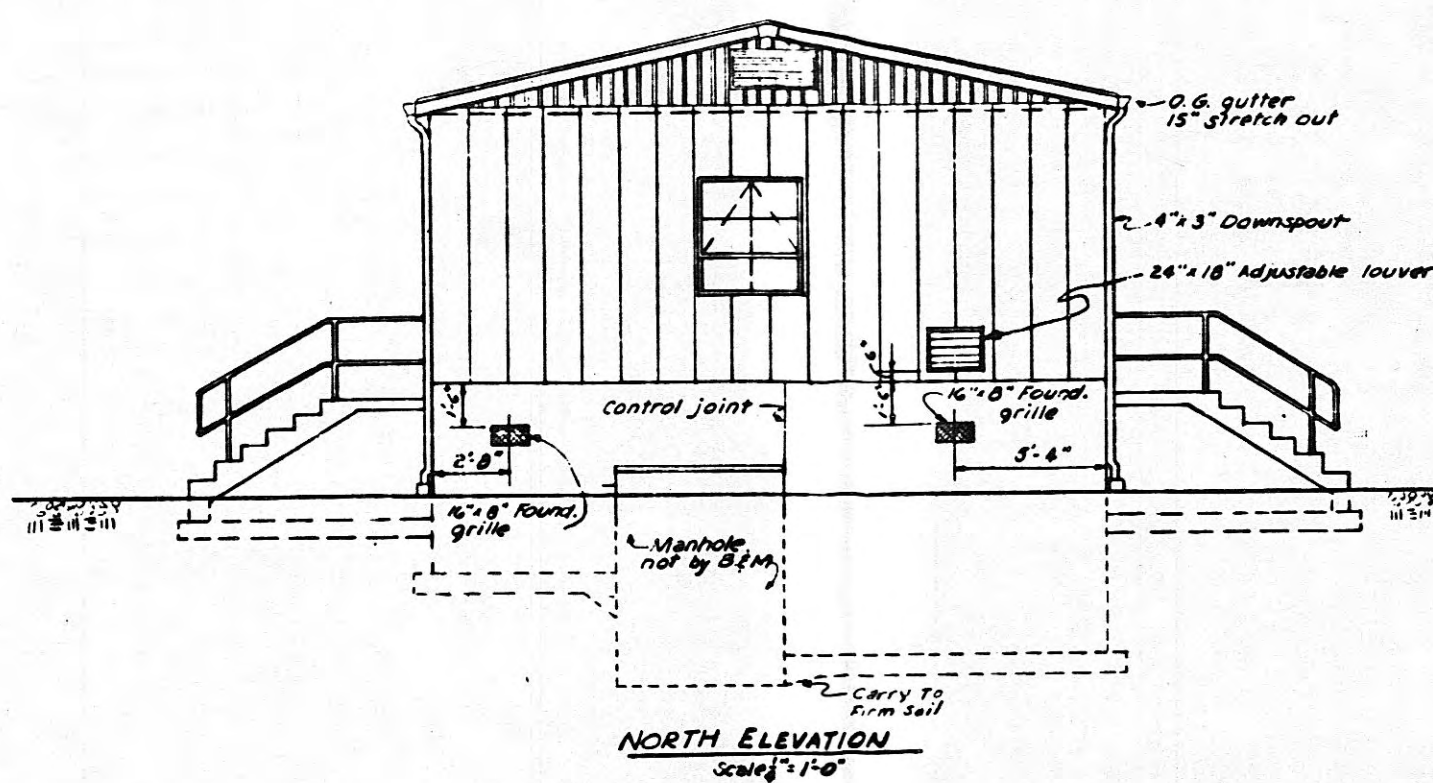

NORTH ELEVATION
Scale $\frac{1}{4}" = 1'-0"$

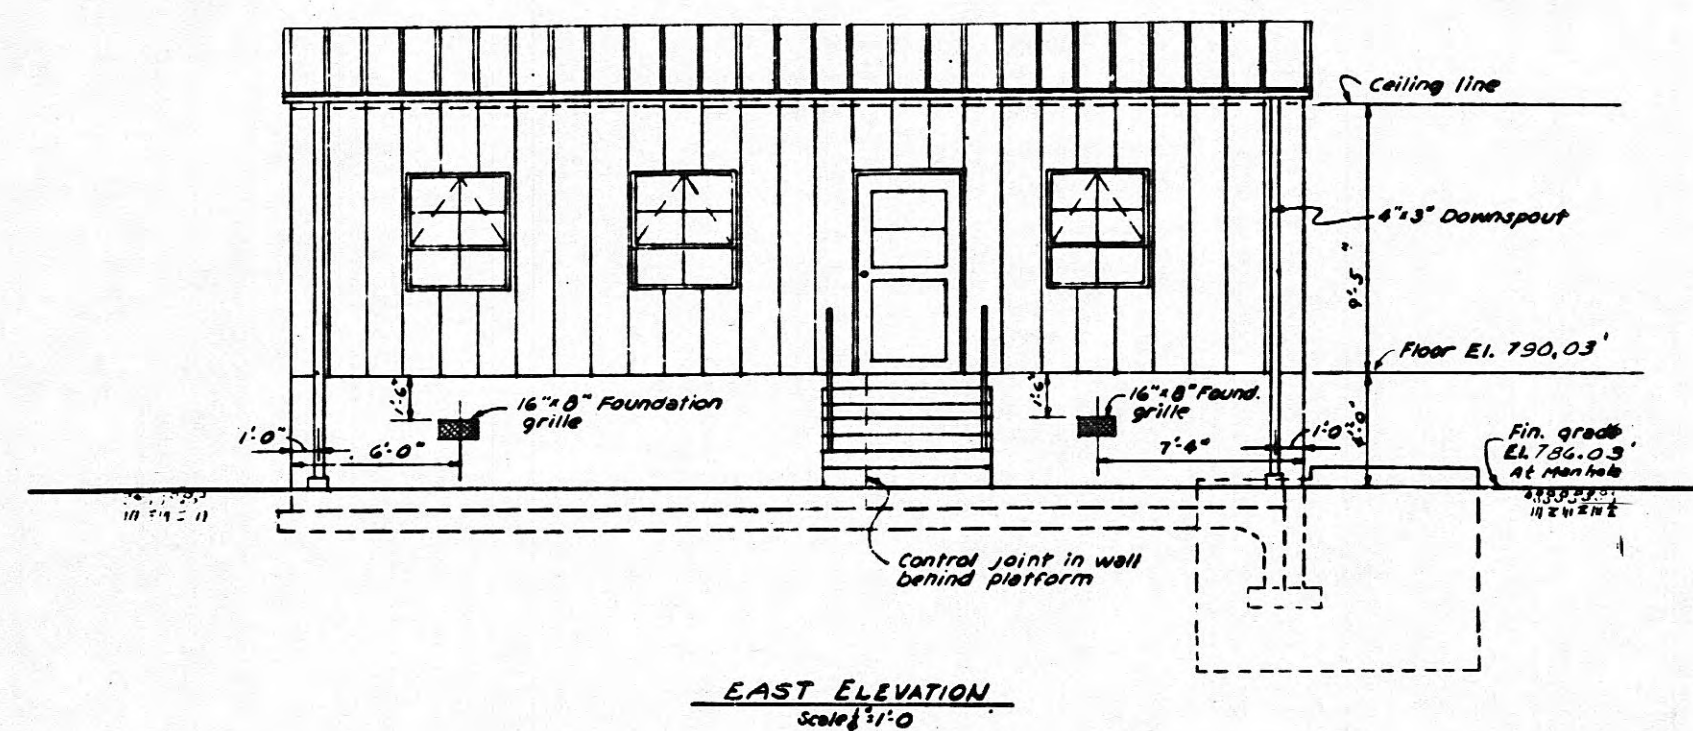

EAST ELEVATION
Scale $\frac{1}{2}$ " = 1'-0"



TENNESSEE VALLEY AUTHORITY
DIVISION OF POWER PLANNING AND ENGINEERING
HARRIMAN TENN. SUB: 1G1KV
24"x36" METAL SWITCH HOUSE
ELEVATIONS

[illegible]


MICROFILMED_____

083595


ES 279-77

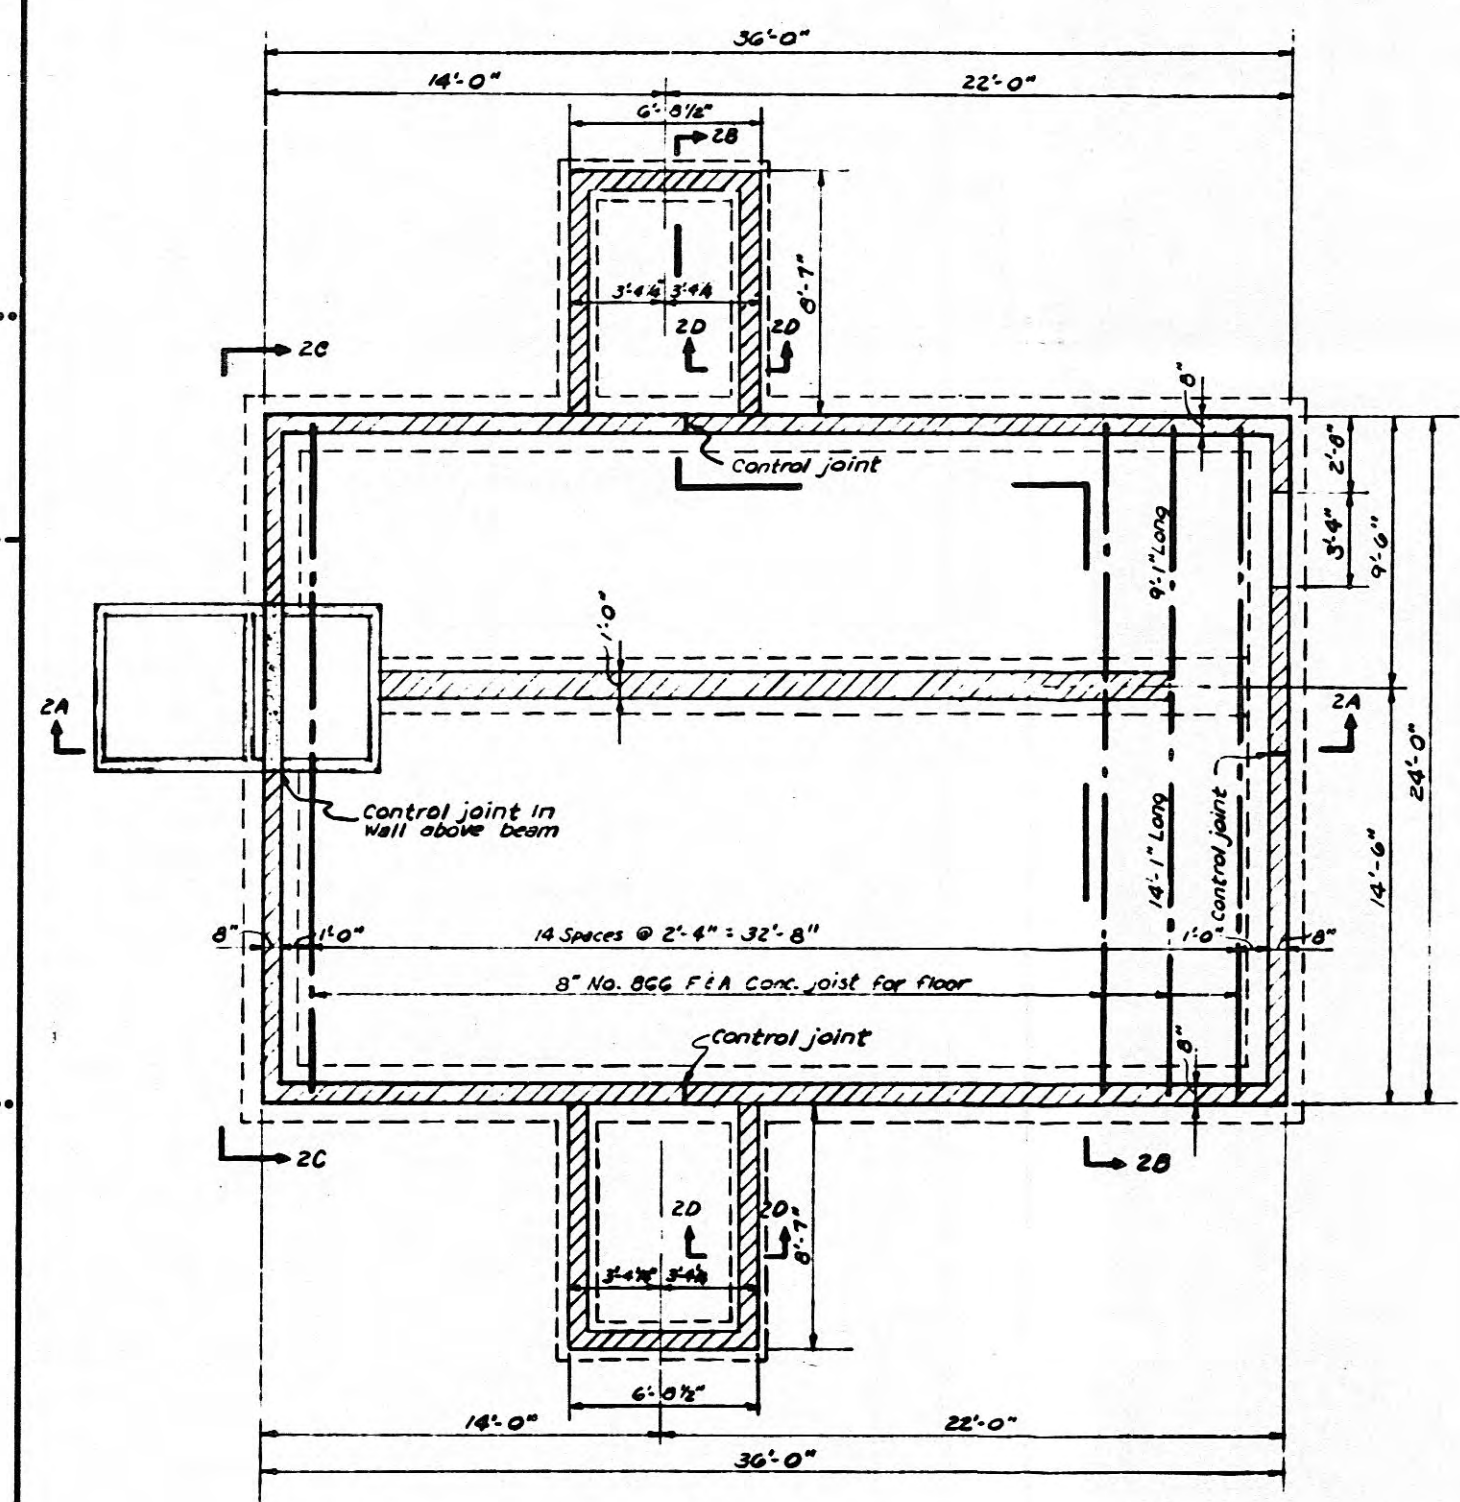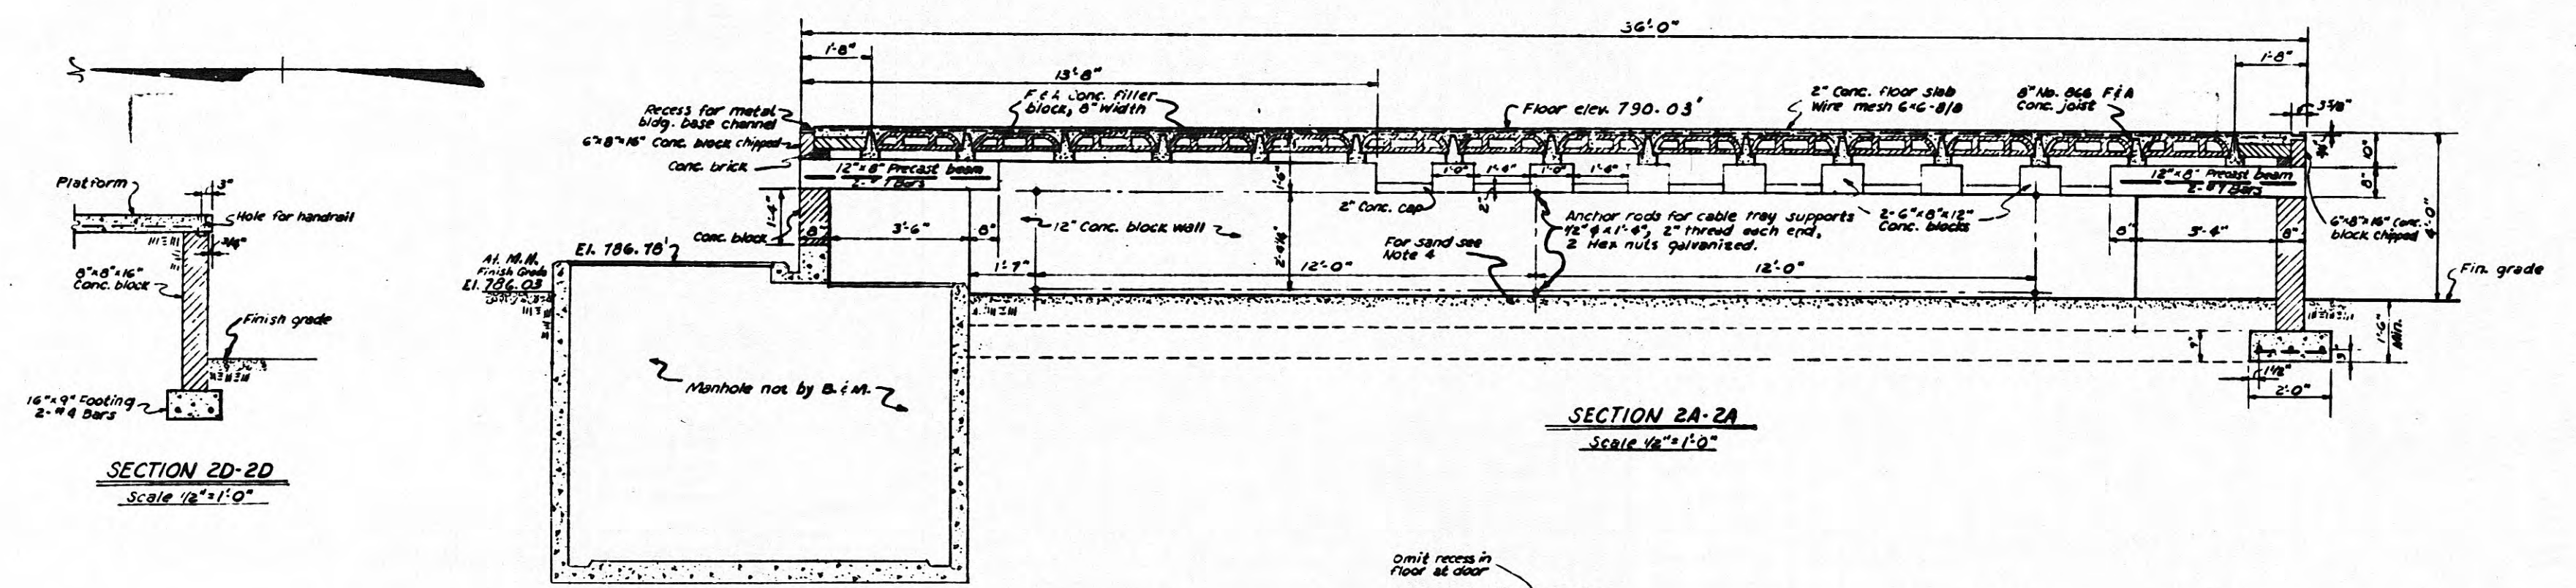

FOUNDATION PLAN
Scale 1/4"=1'-0"

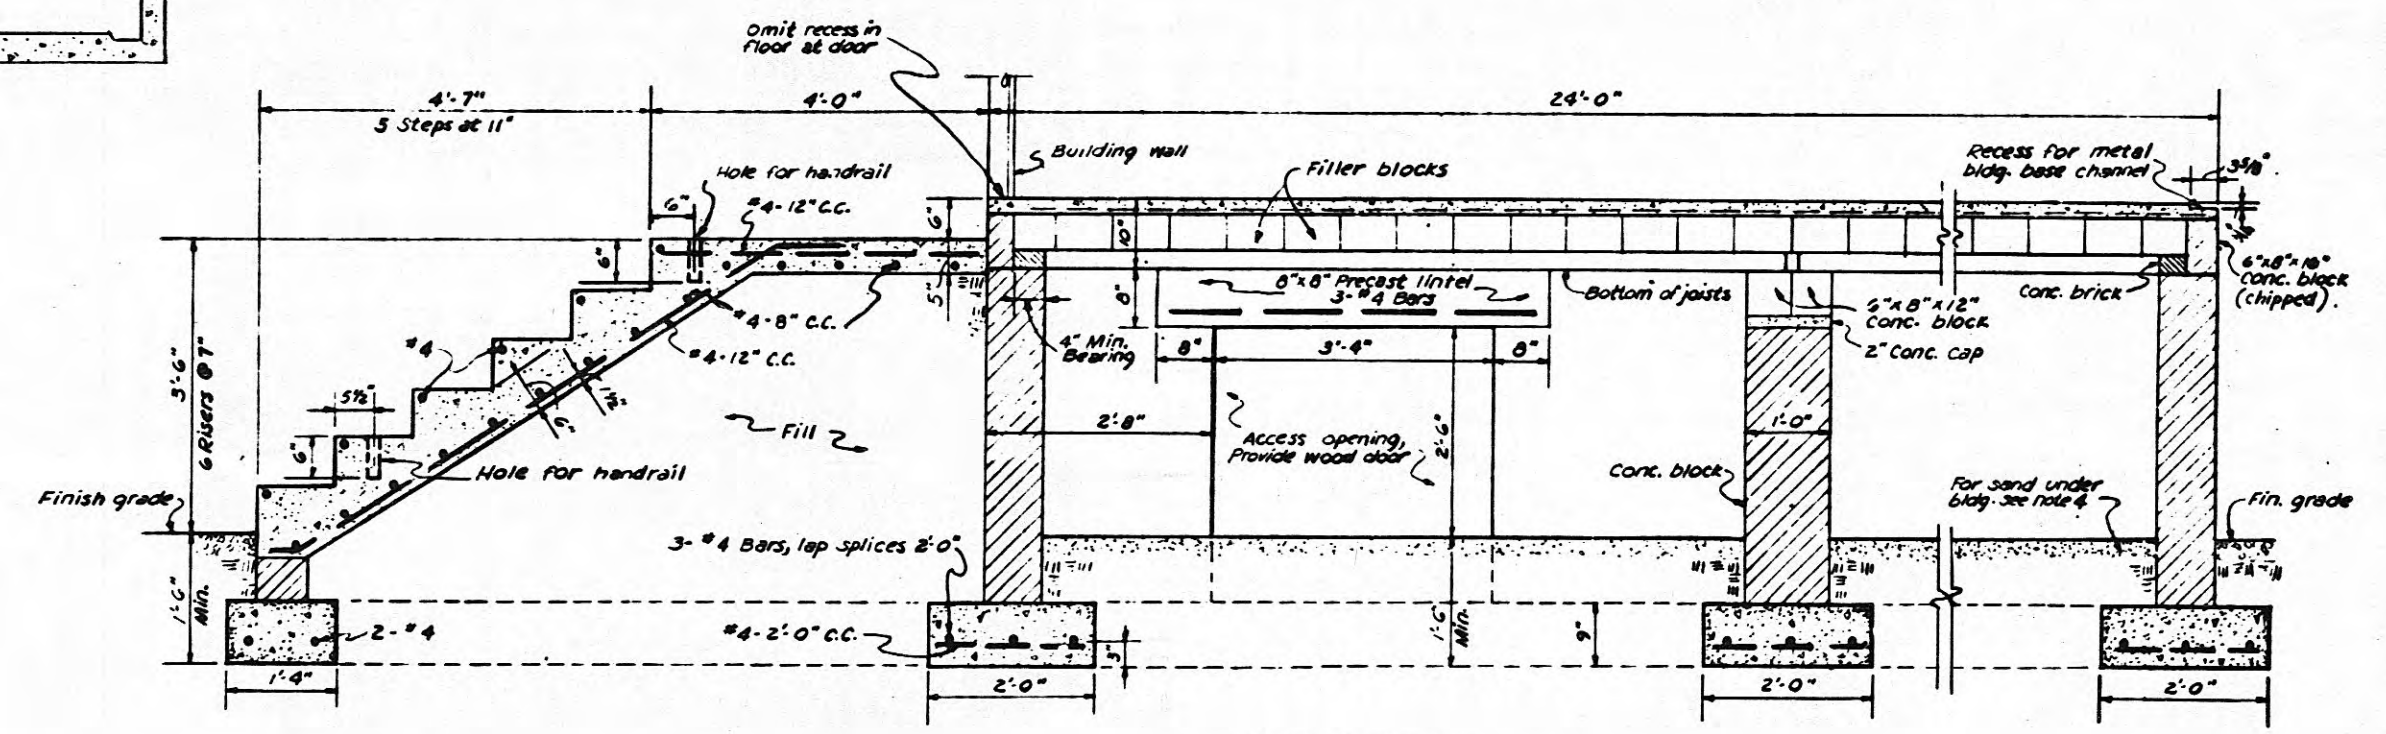

SECTION 2B-2B
Scale 3/8"=1'-0"

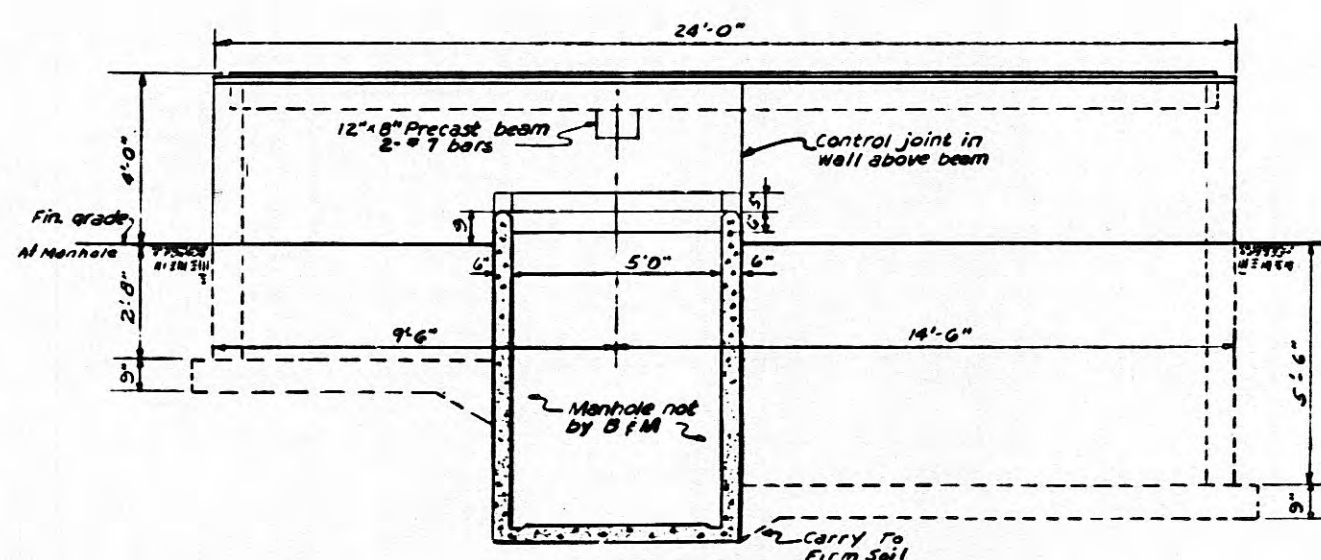

SECTION 2C-2C
Scale 3/8"=1'-0"

- NOTES:**
1. Filler blocks and joists to be thoroughly wet down before concrete floor slab is poured.
 2. Electricians to ground metal building before wood furring and wall board are installed.
 3. See manufacturer's drawings for location of anchor bolts for metal building.
 4. Layer of sand over entire area under bldg. with a min. of 2" on existing sub lots and 3" on new sub lots. Top of sand to be at same elev. as finish grade.

- REFERENCES:**
- Switch House General Arrangement Plan --- LC-46651
 - Switch House Conduit and Lighting Plan --- LC-46652
 - Conc. Details of Manhole for Sw. House --- LC-46682
 - Switch House Handrails --- HC-44217

TENNESSEE VALLEY AUTHORITY
DIVISION OF POWER PLANNING AND ENGINEERING
HARRIMAN TENN. SUB: 161KV
24'x36' METAL SWITCH HOUSE
FOUNDATION PLAN AND SECTIONS

REV.	DATE	BY	CHKD.	APPD.	REASON
1	7/15/66	J.S.			
2					
3					
4					
5					

MICROFILMED

083596

LC-46654

Match Line for Sheet 4

BASE LINE 'A'

For Conduits in Switch House
See LC-46652

For continuation see Key Plan

Match Line for Sheet No. 2

REFERENCES
Bill of Material - BMC-46655
Conduit and Cable List - CMC-46656

TENNESSEE VALLEY AUTHORITY
DIVISION OF POWER PLANNING AND ENGINEERING

HARRIMAN, TENNESSEE SUBSTATION-161KV
OUTDOOR CONDUIT AND LIGHTING
PLAN AND DETAILS

Revised Transite Duct Run									
1	5/24/61	35687	JAB	JAB	WEP	EEB-REH			
NO.	DATE	WORK ORDER	DESIGN	REVIEW	CHECK	SUPPLY	APPROV		
DATE							36861		
DESIGN	JDE, MHR								
CHECK	EEB, BAC								

DATE 5-1-64
SCALE 1"=10'
SHEET 3 OF 9
LC-46654-1

